


SEAL:

THIS DOCUMENT IS NOT
FOR REGULATORY
APPROVAL, PERMITTING,
OR CONSTRUCTION.

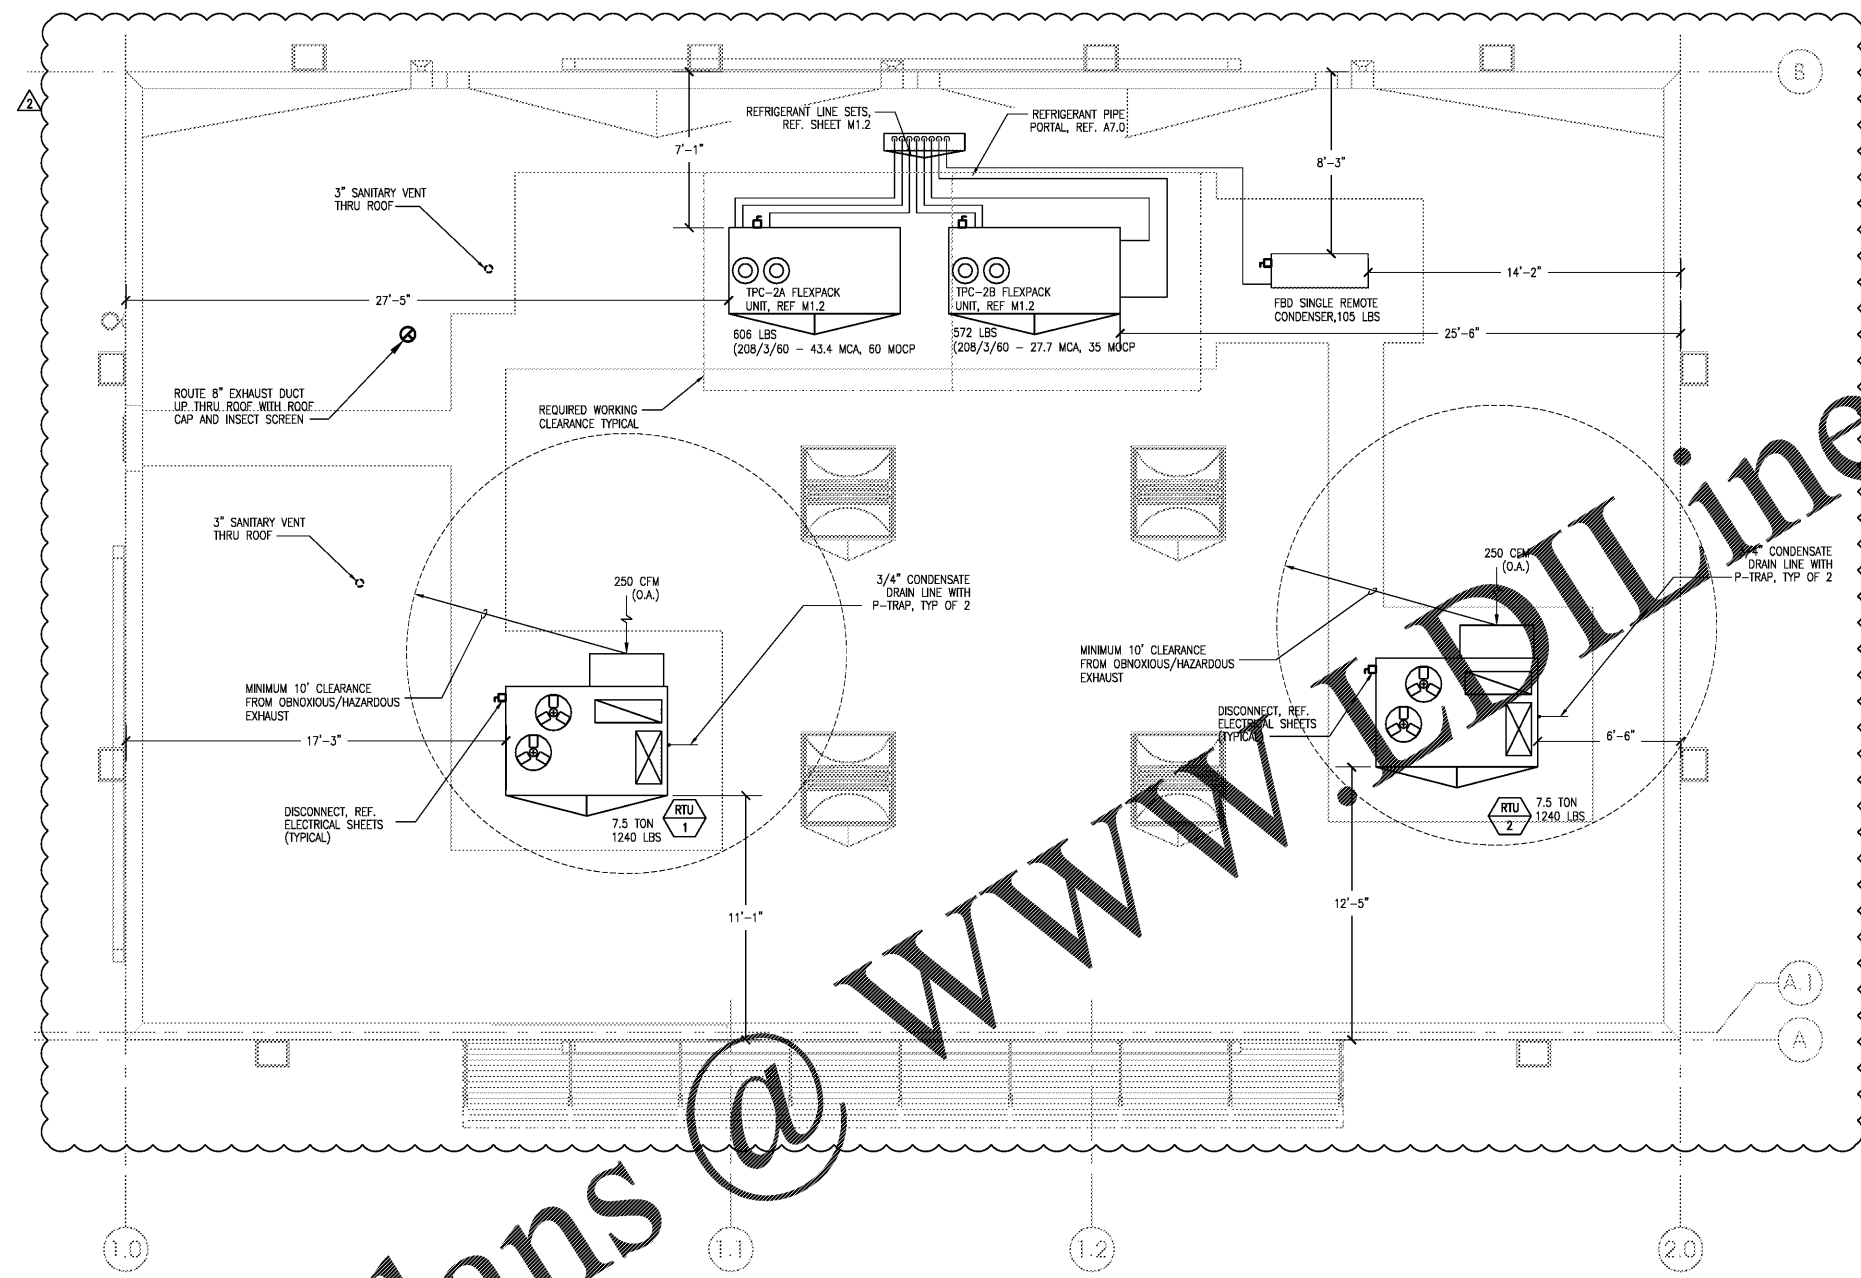

1 MECHANICAL ROOF PLAN
1/4" = 1'-0"



Order Plans @

WWW.EdiLine.com

NO.	DATE	REVISIONS	REMARKS
2	03.06.19	BLDG. DEPT.	COMMENTS
1	03.04.19	FEED REVIEW	



BID SET
APRIL 03, 2019

7-ELEVEN
STORE #38684

SR 60 E. & S BUCK MOORE RD.
LAKE WALES, FL
33898

PROJECT NO: 2018.0616
DATE: DECEMBER 7, 2018

M1.1
MECHANICAL ROOF PLAN

CHECKED: MM DRAWN: LE

COPYRIGHT © 2019 INTERPLAN LLC. REPRODUCE OR TRANSMIT IN ANY FORM OR BY ANY MEANS WITHOUT PERMISSION IS PROHIBITED.