

BARDSTOWN ROAD  
LOUISVILLE, KY




133 Orange Pike East  
Louisville, KY 40210  
Phone: 502-261-3321  
Fax: 502-261-3322




Mechanical Plan

JOB NO. 19-1033  
DATE 03/20/19  
DRAWN IBT  
CHECKED DHS

SHEET  
M-1.0

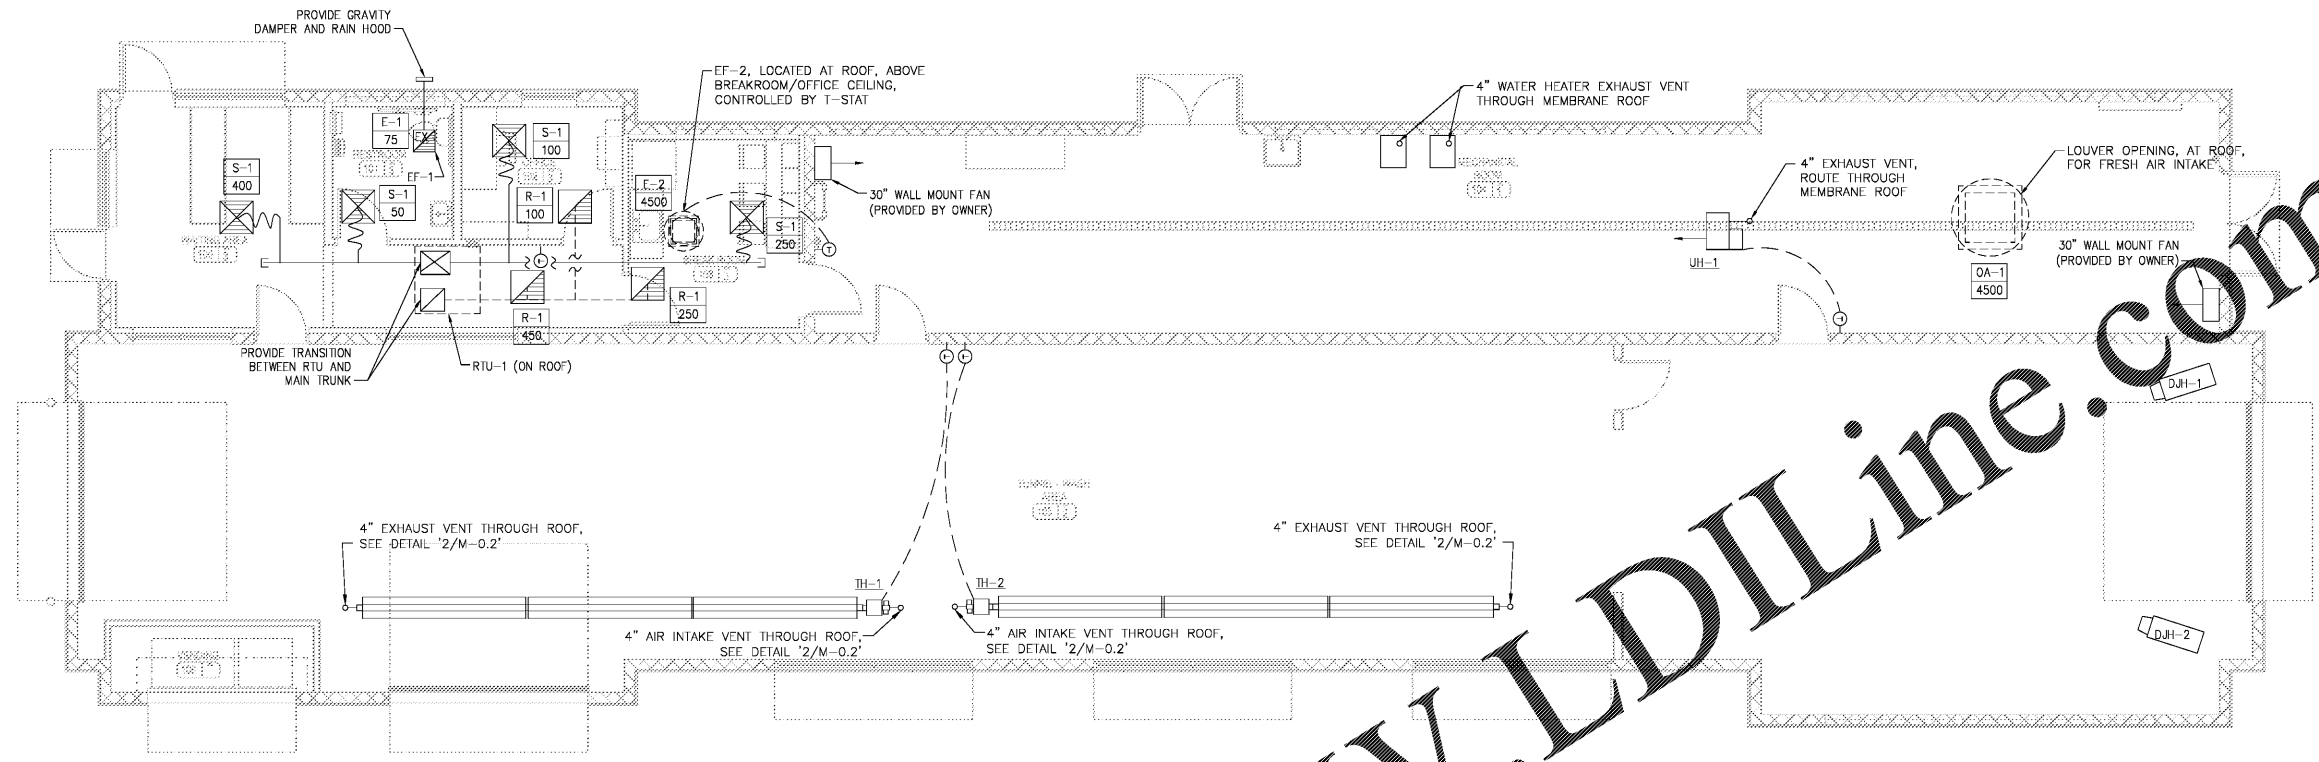

**A** HVAC PLAN - MAIN FLOOR  
M-1.0 SCALE: 3/16" = 1'-0"

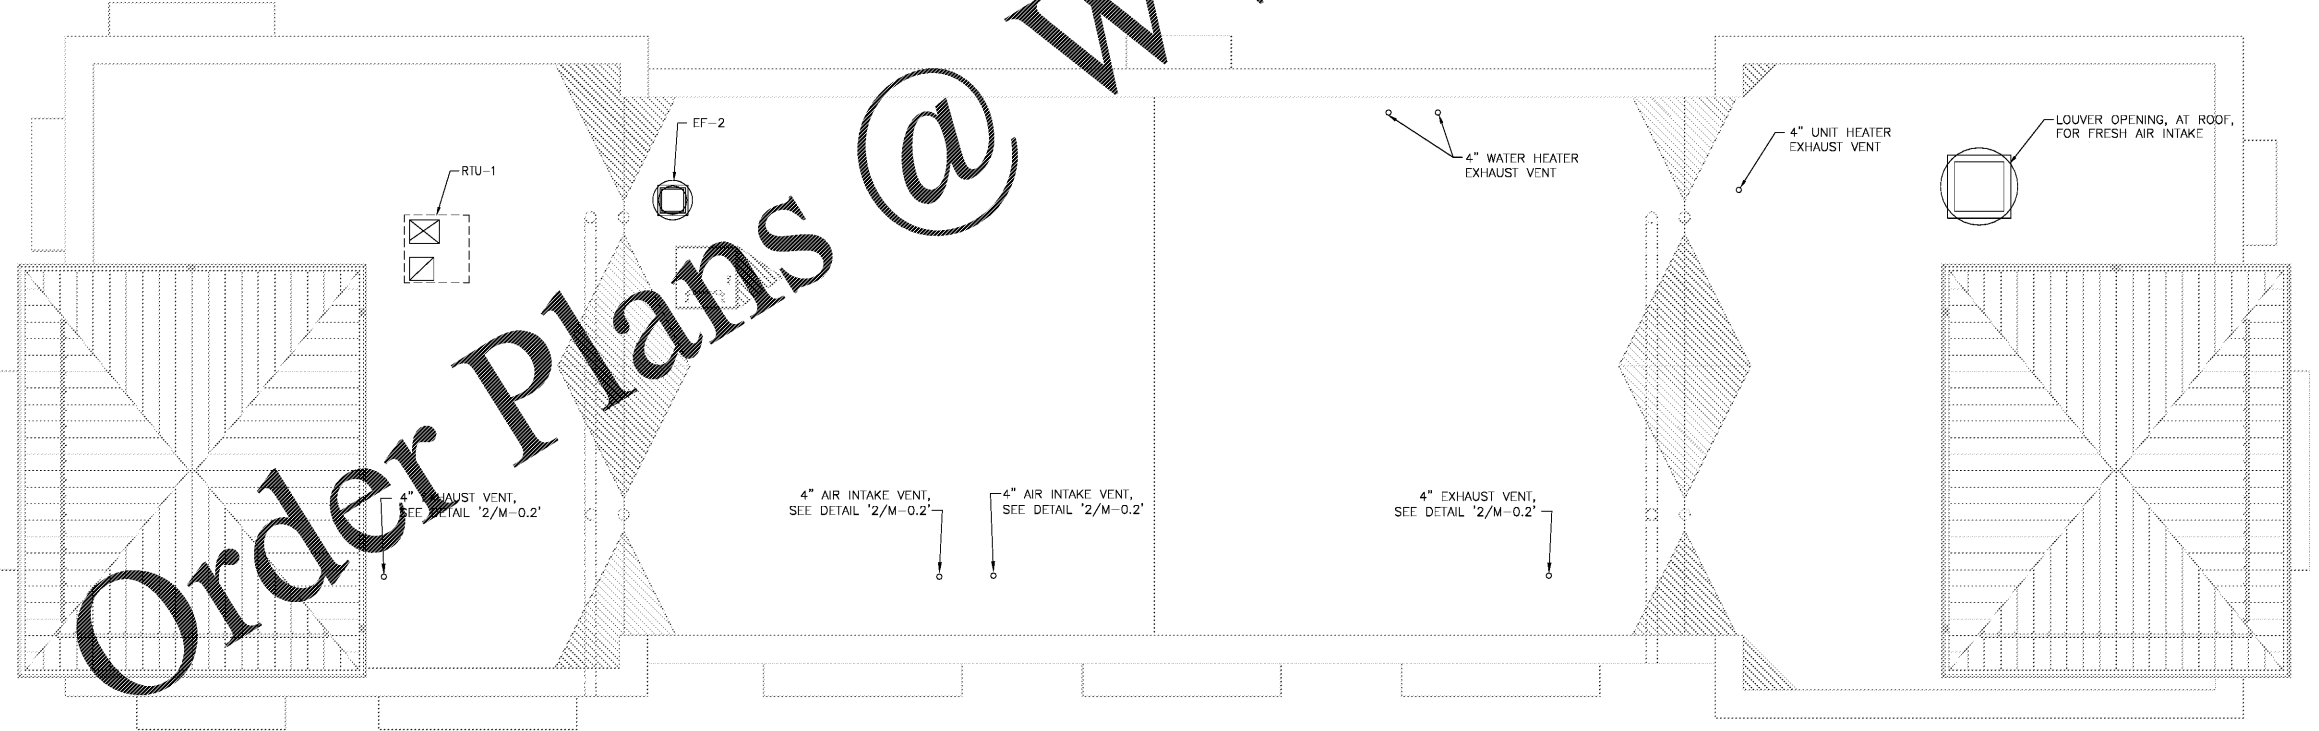

**B** HVAC PLAN - ROOF  
M-1.0 SCALE: 3/16" = 1'-0"

Order Plans @ WWW.LDILine.com