


NOTE: COORDINATE EXACT LOCATION OF RECEPTACLE & LIGHT WITH MECH. CONTR. SO AS NOT TO BLOCK ACCESS PANELS

A RTU LIGHT/RECEPTACLE
E-1.1 N.T.S.

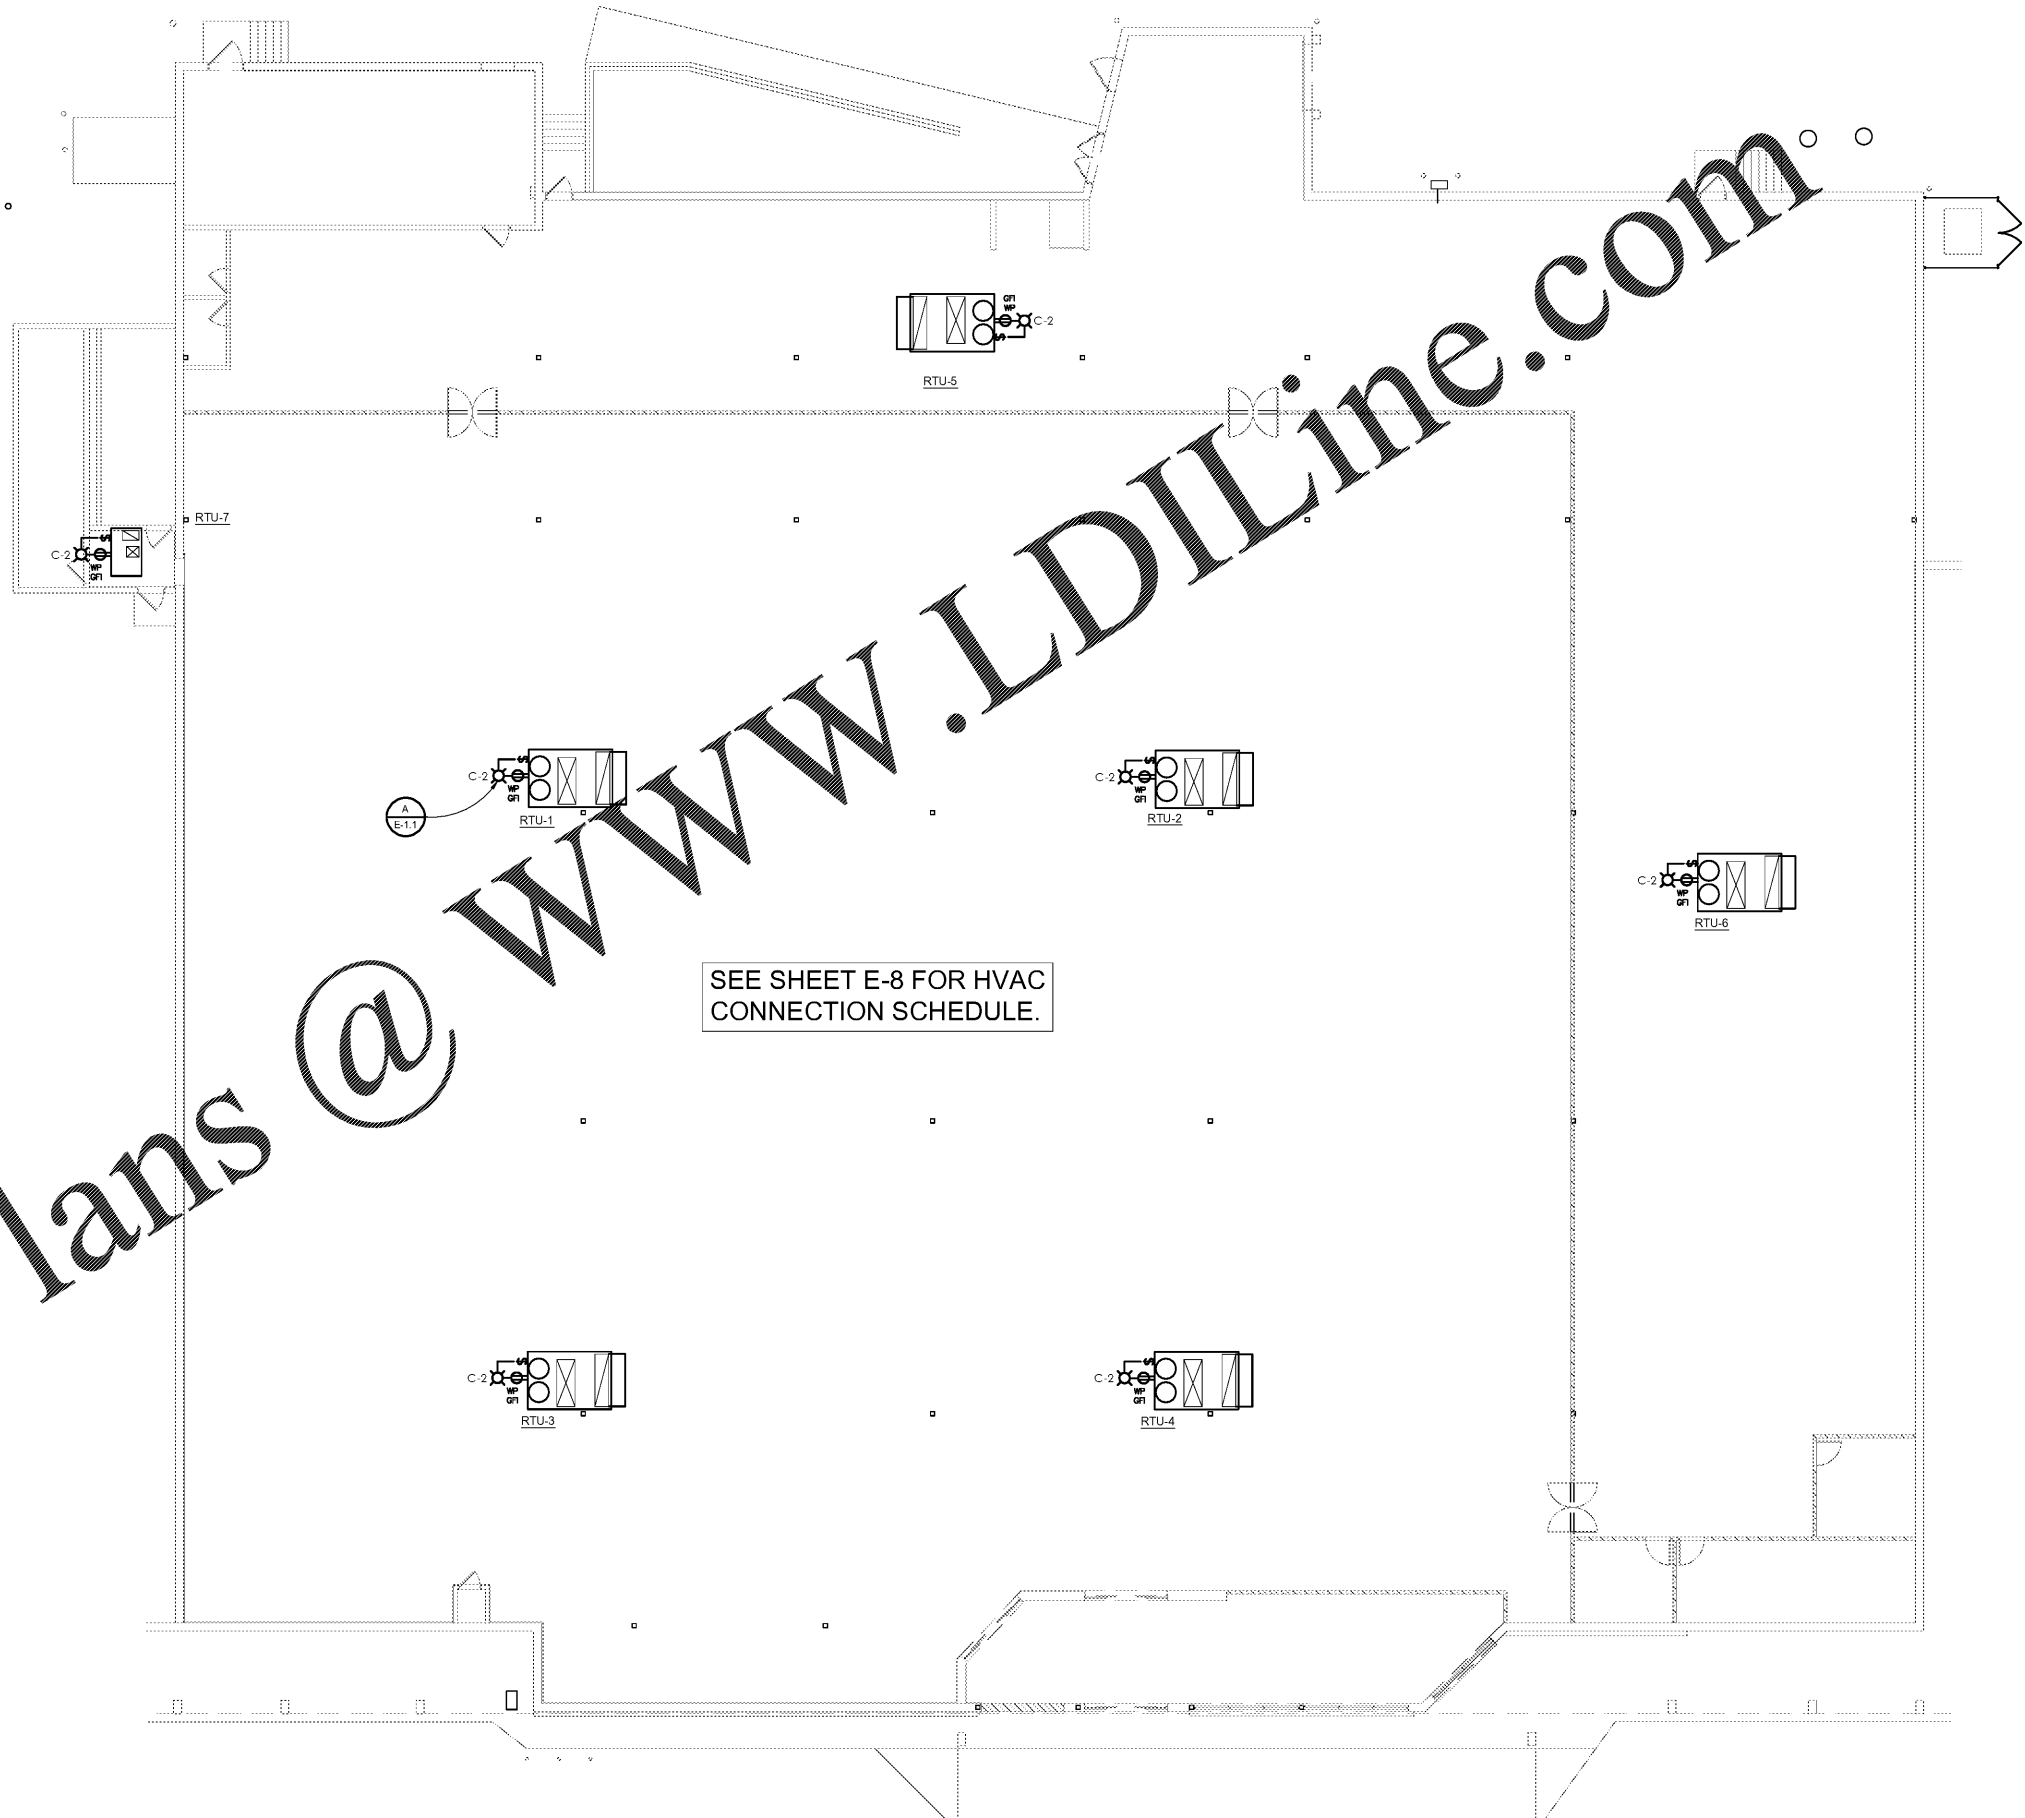

Order Plans @ www.LDILine.com

DATE		REVISION	
DATE DRAWN:		SQUARE FOOTAGE	
04-02-19	Area	SALES FLOOR	TOTAL BUILDING
DRAWN BY:	25,685	39,910	
F.A.	SCALE: 3/32" = 1'-0"		
BIG LOTS STORES, INC. STORE PLANNING DEPT. 4900 E. DUBLIN GRANVILLE RD COLUMBUS, OHIO 43081 PHONE: (614) 278-6800			
SHEET:		E-1.1	

ELECTRIC ROOF PLAN