

GENERAL NOTES

- REFER TO SHEET P1.1 FOR GENERAL NOTES

KEYED NOTES

- 01 PIPE INDIRECT WASTE FROM NEW CASE TO EXISTING HUB DRAIN. VERIFY EXISTING HUB DRAIN LOCATION IN FIELD AND ADJUST IF NECESSARY TO ACCOMMODATE NEW CASE. SEAL ANY NEW PENETRATIONS BETWEEN CASES.
- 02 PROVIDE MAGIC VENT AIR ADMITTANCE VALVE IN ACCESSIBLE LOCATION BENEATH CASE.
- 03 RISE C.I. VENT UP EXPOSED TO BAR JOIST.

Design and Construction Documents are instruments of service as given in accordance and remain the property of Bondurant Associates. No part of these construction documents for purposes other than the specific project named herein may be reproduced, stored in a retrieval system, or transmitted in any form or by any means without the written permission of Bondurant Associates.

Date: SEPTEMBER 10, 2019 Job No. 1922

Revisions:	No.	Date	By	Check


BONDURANT ASSOCIATES
ENGINEERING & ARCHITECTURE
444 CLAYBANK STREET
PORTSMOUTH, VIRGINIA

BRAND ENGINEERING, INC.
NC LICENSE NO. C-1504
2840 POLO PARKWAY, SUITE 200
MIDLOTHIAN, VA 23113
PHONE: (804) 794-8588
FAX: (804) 794-8588
EMAIL: brand@brandeng.com

Harris Teeter
Neighborhood Food & Pharmacy


Project: **HARRIS TEETER STORE #289 ~ REMODEL**
2603 GLENWOOD AVENUE, SUITE 101
RALEIGH, NC 27608
Title: **PLUMBING DRAINAGE PIPING PLAN**

Sheet 03 of 10
P2.1
19077P21.dwg

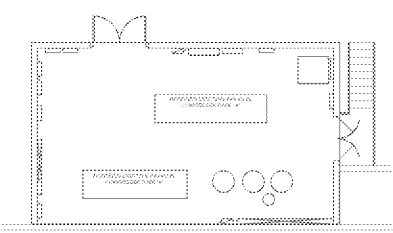

MEZZANINE PLAN

0 2' 4' 8' 16'
SCALE: 1/8"=1'-0"
N

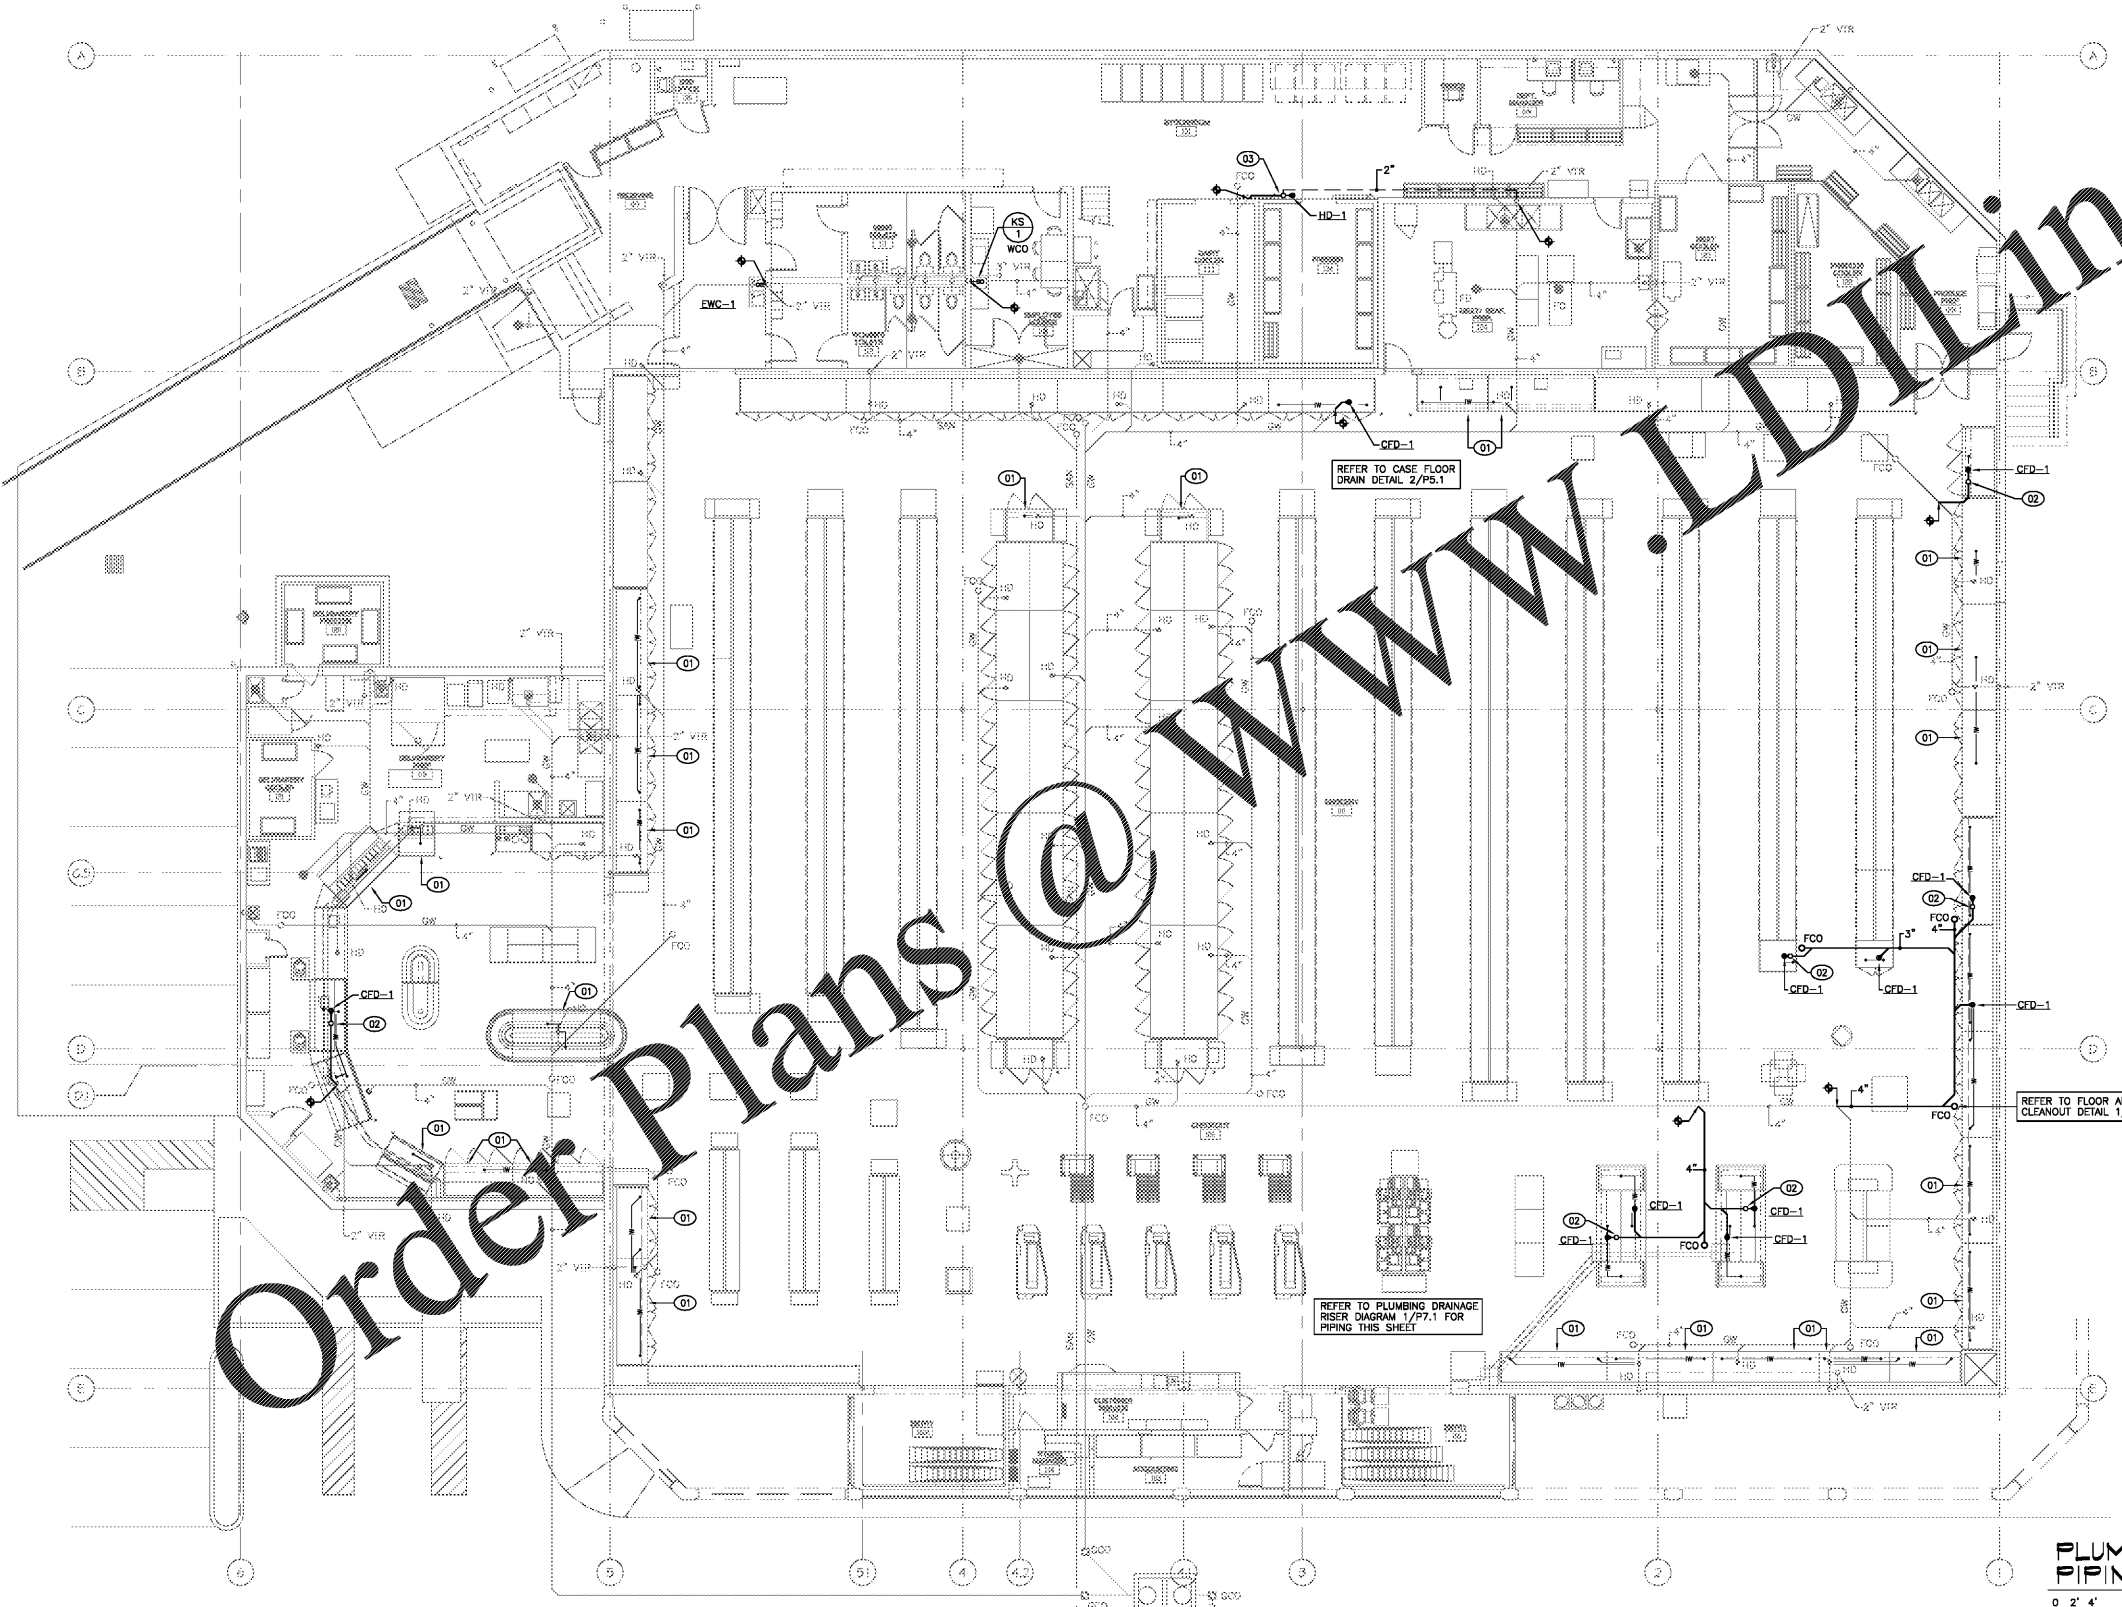

PLUMBING DRAINAGE PIPING PLAN

0 2' 4' 8' 16'
SCALE: 1/8"=1'-0"
N

[Signature]
SEAL
027092
ENGINEER
JOHN S. BARKER
9/10/19

NOTE: THIS DOCUMENT MAY HAVE BEEN ELECTRONICALLY TRANSMITTED. IF UNSIGNED, IT CANNOT BE FILED FOR PUBLIC RECORD. PUBLIC RECORD FILINGS REQUIRE SIGNED AND SEALED DOCUMENTS.

Order Plans @ www.JDIDline.com