


9/10/2019 8:46:54 AM

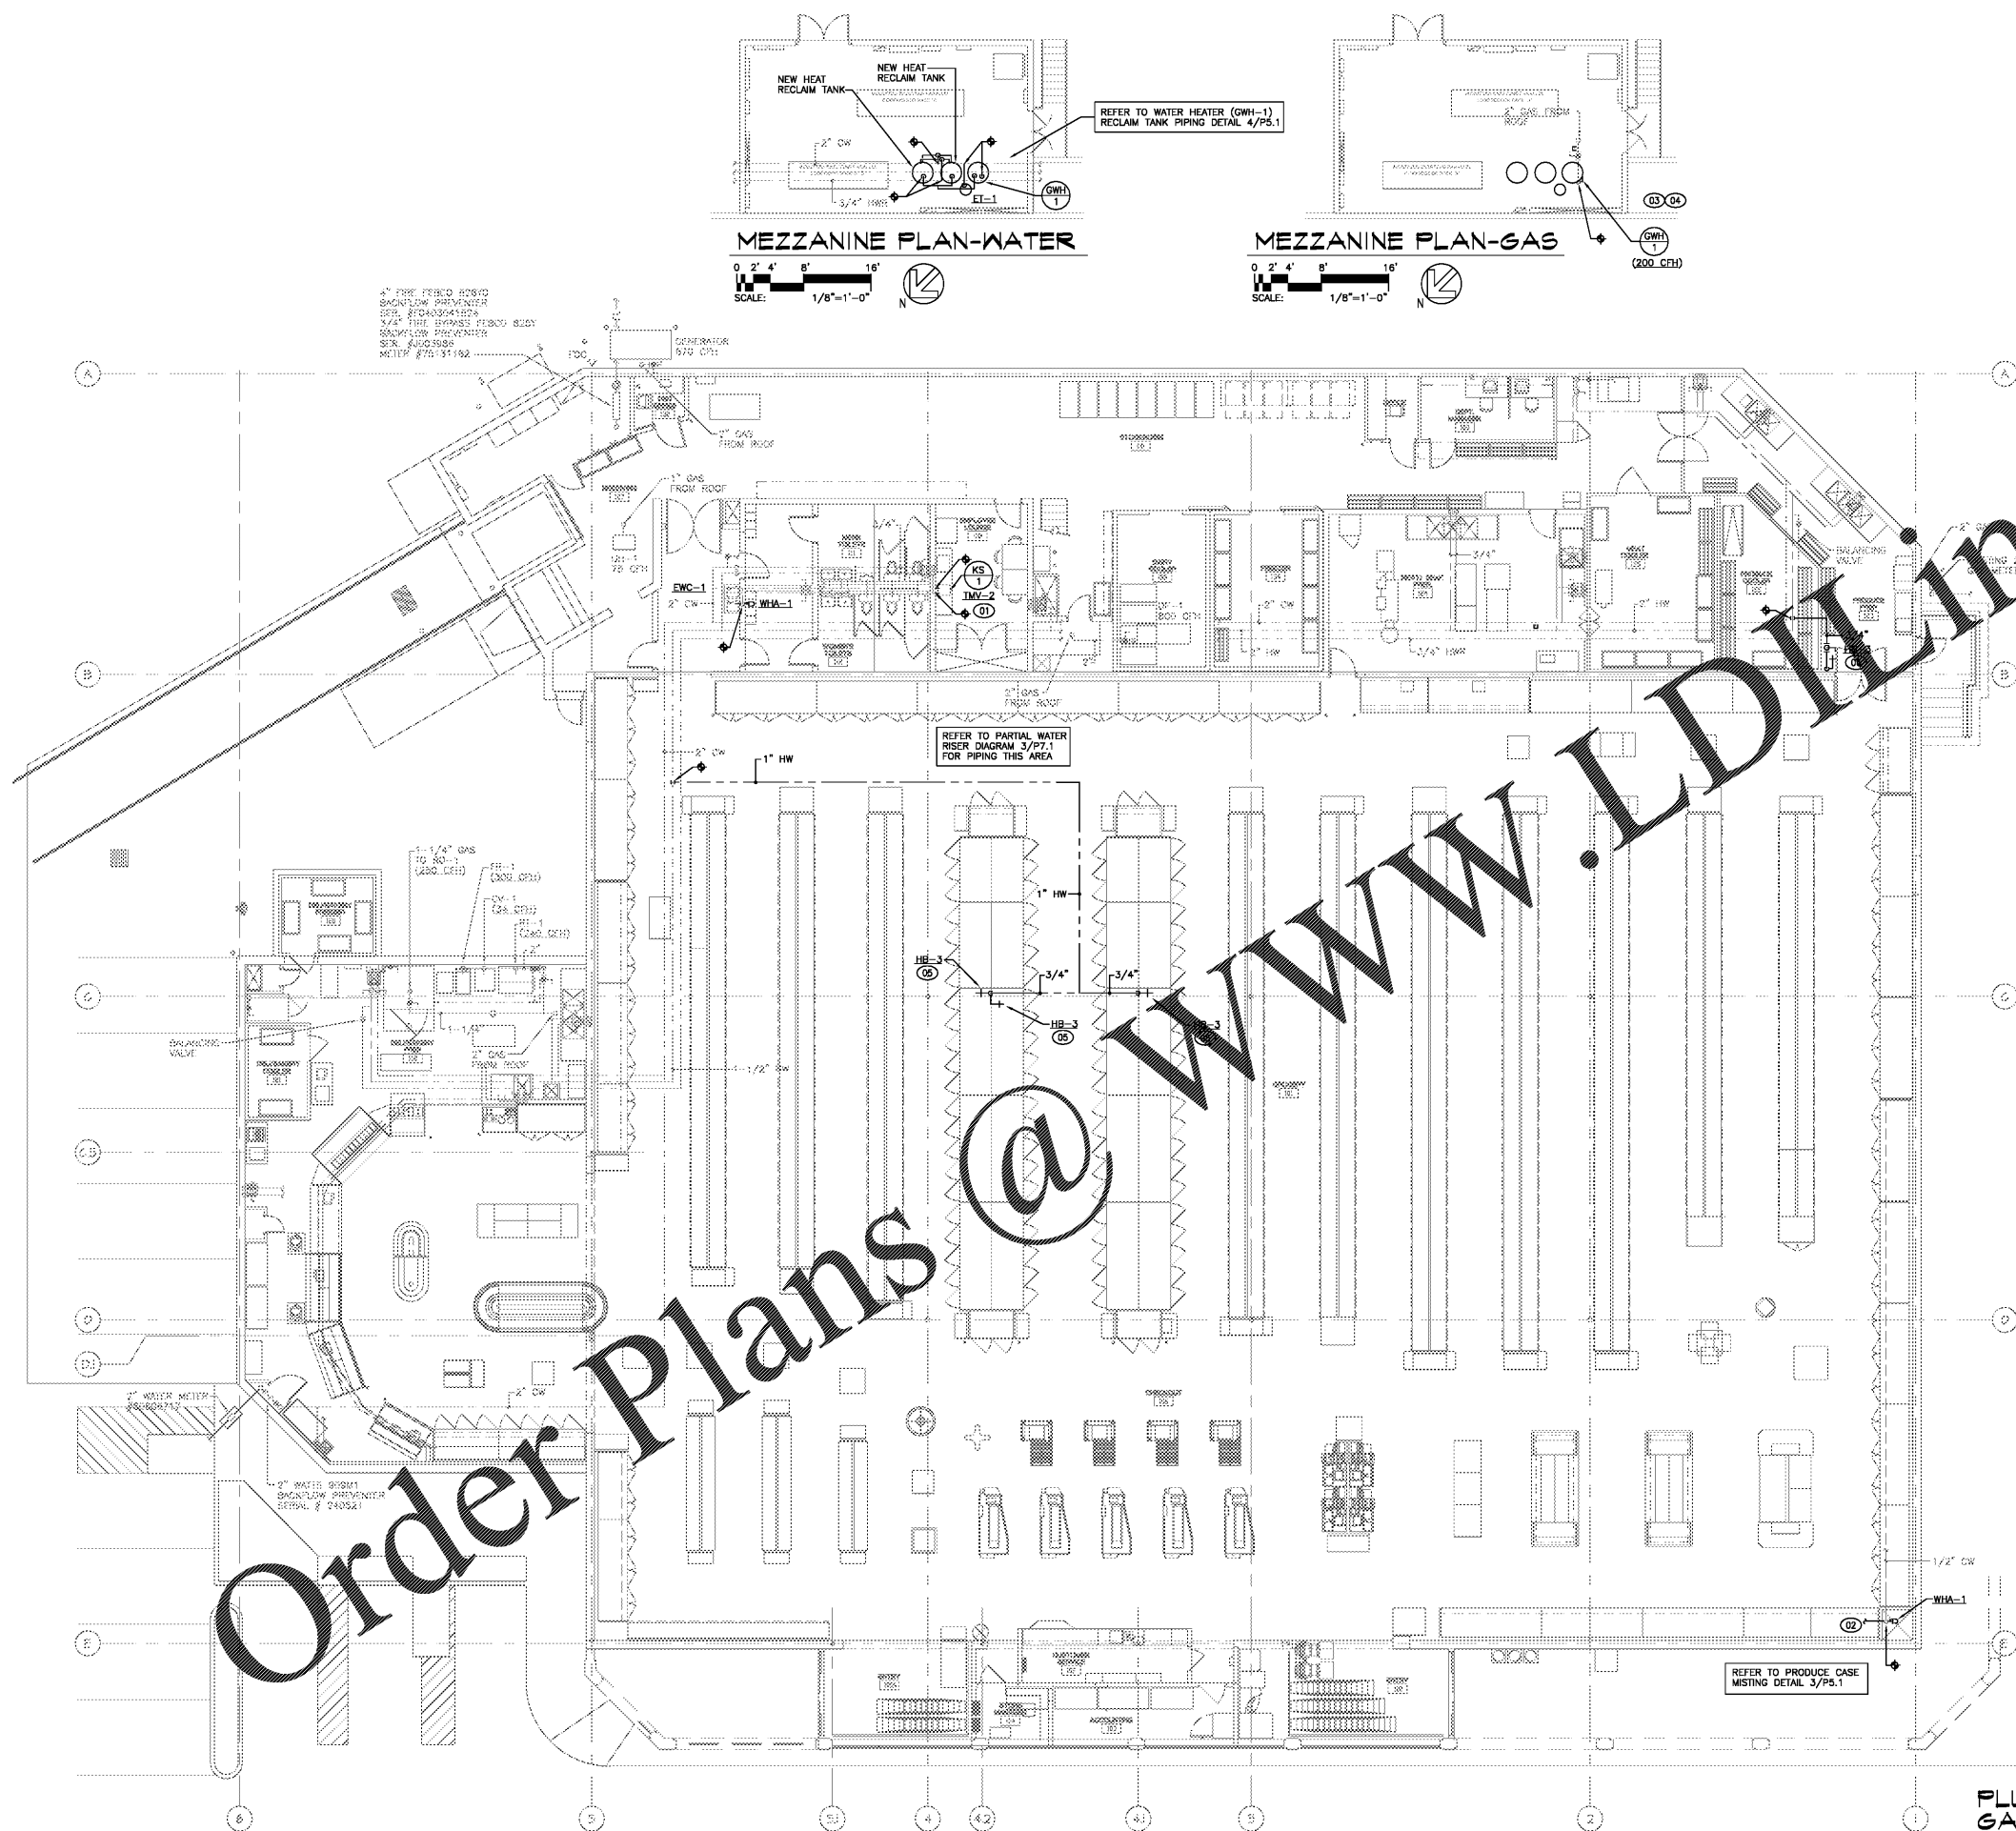

GENERAL NOTES

- REFER TO SHEET P1.1 FOR GENERAL NOTES

KEYED NOTES

- MOUNT TMV IN ACCESSIBLE LOCATION BENEATH SINK.
- CONNECT NEW CASE MISTING SYSTEM TO EXISTING COLD WATER PIPING. PROVIDE SHUT OFF VALVE AND BACKFLOW PREVENTER IF NOT EXISTING. COORDINATE ADDITIONAL REQUIREMENTS WITH MISTING SYSTEM PROVIDER.
- CONNECT NEW WATER HEATER TO EXISTING GAS PIPING.
- CONNECT NEW WATER HEATER TO EXISTING INTAKE AND EXHAUST FLUES. REFER TO GAS FIRED WATER HEATER/RECLAIM PIPING TANK DETAIL 4/PS.1.
- MOUNT HOSE BIB AT AFF. VERIFY LOCATION WITH HARDWARE SUPPLIER.
- MOUNT HOSE BIB 12" AFF. VERIFY LOCATION WITH HARDWARE SUPPLIER.


Design and Construction Documents are instruments of service as given in accordance with the terms and conditions of the contract. These construction documents are for the specific project named herein and are not to be used for any other project. No part of this document may be reproduced, stored in a retrieval system, or transmitted in any form or by any means without the written permission of Bondurant Associates.

Date: SEPTEMBER 10, 2019 Job No. 1922

Revisions:	No.	Date	By	Check

AREA OF WORK PLAN

REFERENCE SHEET C1.2 - AREA OF WORK PLAN FOR DELINEATION OF INDIVIDUAL WORK AREAS WITHIN THE PROJECT.

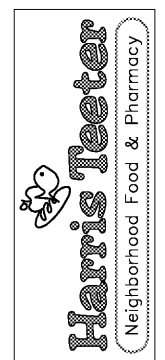

Project: **HARRIS TEETER STORE #289 - REMODEL**
 2603 GLENWOOD AVENUE, SUITE 101
 RALEIGH, NC 27608

Title: **PLUMBING WATER AND GAS PIPING PLAN**

John S. Park
 SEAL
 027092
 ENGINEER
 JOHN S. PARK
 9/10/19

PLUMBING WATER AND GAS PIPING PLAN

SCALE: 1/8"=1'-0"

NOTE: THIS DOCUMENT MAY HAVE BEEN ELECTRONICALLY TRANSMITTED. IF UNSIGNED, IT CANNOT BE FILED FOR PUBLIC RECORD. PUBLIC RECORD FILINGS REQUIRE SIGNED AND SEALED DOCUMENTS.