


**HVAC DEMOLITION MEZZANINE PLAN**

SCALE: 1/8"=1'-0"

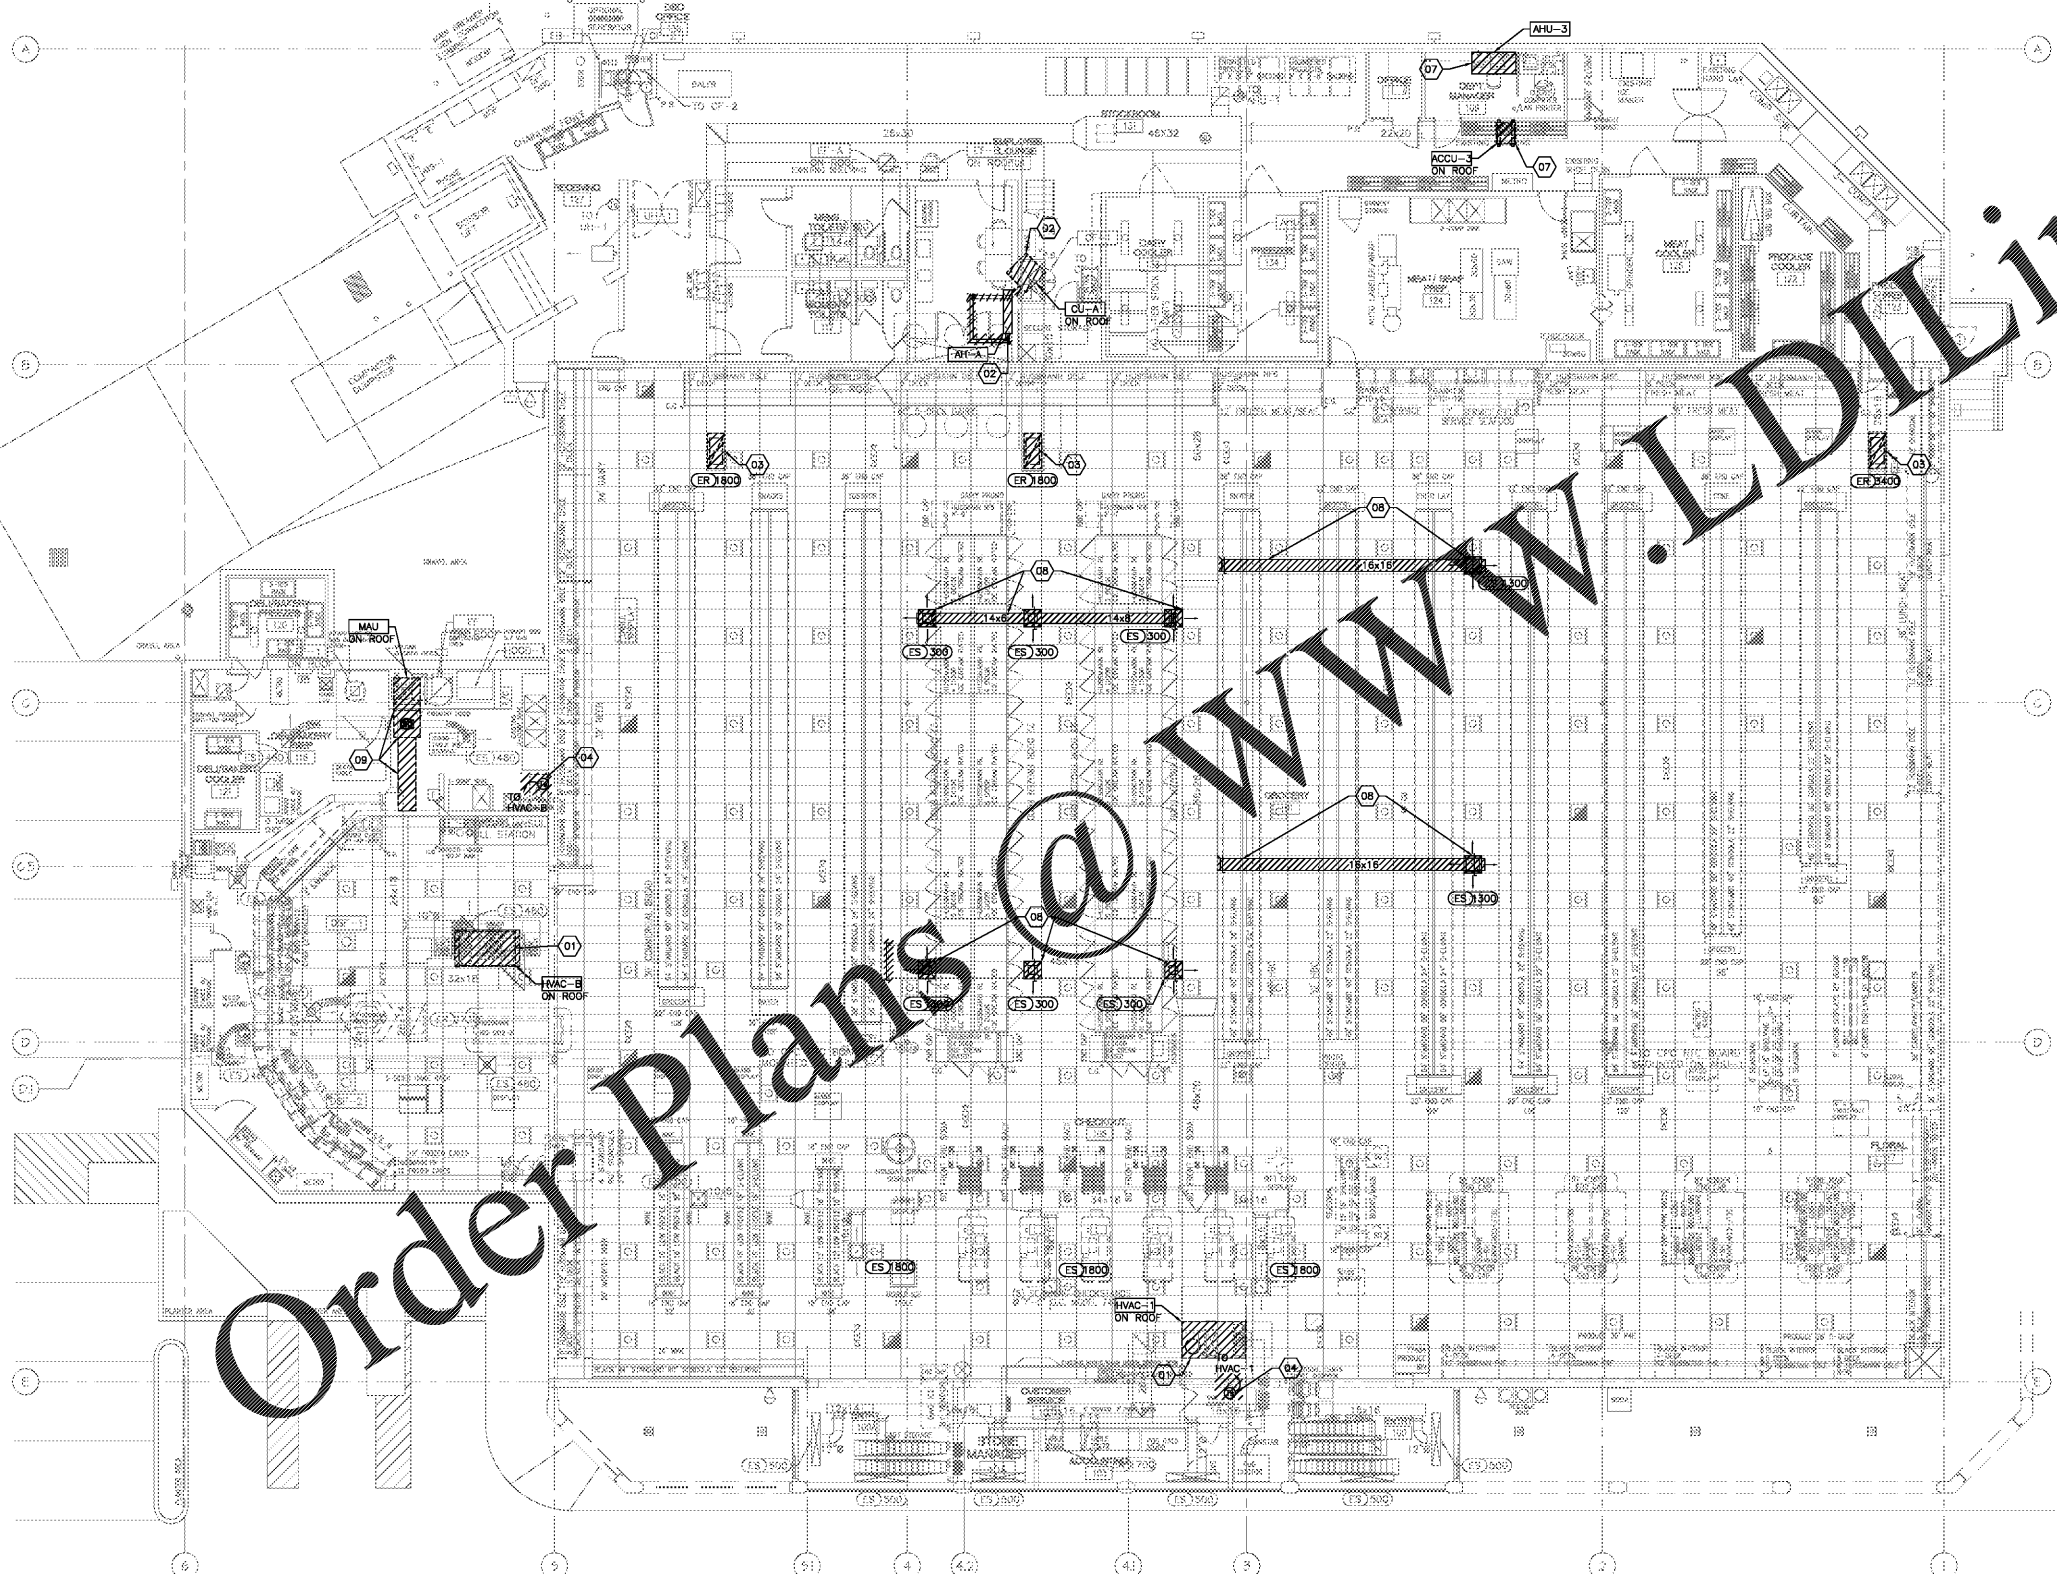

**HVAC DEMOLITION FLOOR PLAN**

SCALE: 1/8"=1'-0"

**DEMOLITION GENERAL NOTES:**

1. THE DEMOLITION PLANS WERE DERIVED FROM EXISTING BUILDING PLANS AND SITE VISITS AND ARE INTENDED TO REASONABLY REPRESENT EXISTING CONDITIONS. HOWEVER, ACTUAL CONDITIONS MAY DEVIATE FROM THAT SHOWN ON THE DRAWINGS. THE DEMOLITION KEY NOTES IDENTIFY SPECIFIC AREAS OF WORK BUT MAY NOT BE COMPLETE IN IDENTIFICATION OF ALL REMOVALS REQUIRED FOR INSTALLATION OF NEW WORK. THE CONTRACTOR SHALL VERIFY ACTUAL CONDITIONS AND COORDINATE THE DEMOLITION WITH NEW WORK SO THAT DEMOLITION IS COMPLETE AS REQUIRED TO NOT OBSTRUCT PROPER EXECUTION OF THE CONTRACT WORK.
2. COORDINATE DEMOLITION/REMOVAL OF EXISTING HVAC EQUIPMENT/SYSTEMS WITH GENERAL CONTRACTOR AND HARRIS TEETER PROJECT MANAGER TO MAINTAIN SYSTEMS OPERATIONAL AS REQUIRED TO ALLOW UNINTERRUPTED STORE OPERATIONS DURING THE COURSE OF THE RENOVATION.

**DEMOLITION KEYED NOTES:**

- 01 REMOVE EXISTING ROOFTOP UNIT, EXISTING ROOF CURB AND DUCTWORK TO REMAIN FOR INSTALLATION OF REPLACEMENT UNIT. FIELD VERIFY EXISTING CURB SIZE AND PROVIDE CURB ADAPTER AS REQUIRED TO ALLOW NEW UNIT TO BE MOUNTED ON EXISTING CURB AND CONNECT TO EXISTING DUCT.
- 02 REMOVE EXISTING WALL MOUNTED DUCTLESS SPLIT SYSTEM AIR HANDLING UNIT, ROOF MOUNTED CONDENSING UNIT, PIPING AND ASSOCIATED HANGERS, SUPPORTS AND MISCELLANEOUS APPURTENANCES AS INDICATED OR REQUIRED FOR INSTALLATION OF REPLACEMENT UNITS. SEE RENOVATION PLAN FOR REPLACEMENT UNITS.
- 03 REMOVE EXISTING DUCT/CEILING MOUNTED RETURN AIR DEVICES AS INDICATED AND PROVIDE NEW GRILLES TO MATCH EXISTING. FIELD VERIFY EXISTING GRILLES SIZES AND TYPES PRIOR TO REMOVAL OF EXISTING GRILLES AND PRIOR TO ORDERING NEW GRILLES.
- 04 REMOVE EXISTING WALL MOUNTED TEMPERATURE/HUMIDITY SENSOR. SEE RENOVATION FLOOR PLANS FOR NEW TEMPERATURE AND DEWPOINT SENSOR LOCATIONS.
- 05 REMOVE EXISTING ROOF MOUNTED GRAVITY OUTSIDE AIR INTAKE, DAMPER AND ASSOCIATED HANGERS, SUPPORTS AND MISCELLANEOUS APPURTENANCES AS INDICATED OR REQUIRED TO ALLOW FOR THE INSTALLATION OF THE NEW SUPPLY FAN SF-1 ON THE EXISTING CURB. EXISTING ROOF CURB TO REMAIN FOR INSTALLATION OF REPLACEMENT FAN. FIELD VERIFY EXISTING CURB SIZE AND PROVIDE CURB ADAPTER AS REQUIRED TO ALLOW NEW FAN TO BE MOUNTED ON EXISTING CURB.
- 06 REMOVE EXISTING ROOF MOUNTED EXHAUST FAN, BACKDRAFT DAMPER, CONTROLS AND ASSOCIATED HANGERS, SUPPORTS AND MISCELLANEOUS APPURTENANCES AS INDICATED. FIELD VERIFY EXISTING CURB SIZE AND PROVIDE CURB ADAPTER AS REQUIRED TO ALLOW NEW FAN TO BE MOUNTED ON EXISTING CURB.
- 07 REMOVE EXISTING CEILING MOUNTED AIR HANDLING UNIT, ROOF MOUNTED CONDENSING UNIT, SUPPLY AND RETURN AIR DUCT, CEILING MOUNTED AIR DEVICES AND ASSOCIATED HANGERS, SUPPORTS AND MISCELLANEOUS APPURTENANCES AS INDICATED. CAP EXISTING PIPING PENETRATION AND OUTSIDE AIR INTAKE CURBS. SEE ARCHITECTURAL DRAWINGS FOR CURB CAP DETAILS.
- 08 REMOVE EXISTING DUCTWORK, DIFFUSERS AND ASSOCIATED HANGERS, SUPPORTS AND MISCELLANEOUS APPURTENANCES AS INDICATED BACK TO MAIN AND CAP BRANCH CONNECTION.
- 09 REMOVE EXISTING MAKEUP AIR FAN, ROOF MOUNTED DUCTWORK AND ALL MAKEUP AIR DUCTWORK AND ASSOCIATED HANGERS, SUPPORTS AND MISCELLANEOUS APPURTENANCES AS INDICATED FROM HOOD MAKEUP AIR CONNECTIONS BACK TO FAN CONNECTION AND CAP CURB. SEE ARCHITECTURAL DRAWINGS FOR CURB CAP DETAILS.


**AREA OF WORK PLAN**

REFERENCE SHEET C1.2 - AREA OF WORK PLAN FOR DELINEATION OF INDIVIDUAL WORK AREAS WITHIN THE PROJECT.

**HVAC SHEET LIST**

DRAWING NUMBER	DRAWING TITLE
H0.1	HVAC DEMOLITION FLOOR PLAN
H0.2	HVAC DEMOLITION ROOF PLAN
H1.1	HVAC RENOVATION FLOOR PLAN
H1.2	HVAC RENOVATION ROOF PLAN
H2.1	HVAC DETAILS
H3.1	HVAC SCHEDULES, NOTES, LEGEND AND ABBREVIATIONS

NOTE: THIS DOCUMENT MAY HAVE BEEN ELECTRONICALLY TRANSMITTED. IF UNSIGNED, IT CANNOT BE FILED FOR PUBLIC RECORD. PUBLIC RECORD FILINGS REQUIRE SIGNED AND SEALED DOCUMENTS.

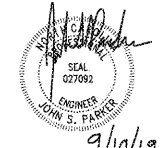

Design and Construction Documents are instruments of service and shall remain the property of Bondurant Associates. No part of these construction documents shall be reproduced, stored in a retrieval system, or transmitted in any form or by any means without the written permission of Bondurant Associates.

Date: SEPTEMBER 10, 2019 Job No. 1922

Revisions:	No.	Date	By	Check

**BONDURANT ASSOCIATES**  
ENGINEERING & ARCHITECTURE  
444 CHAWHORN STREET  
FARMVILLE, VIRGINIA

**BRAND ENGINEERING, INC.**  
NC LICENSE NO. C-504  
2840 POLO PARKWAY, SUITE 200  
MIDLOTHIAN, VA 23103  
PHONE: (804) 794-8588  
FAX: (804) 794-8588  
EMAIL: brand@brandinc.com

**Harris Teeter**  
Neighborhood Food & Pharmacy

Project: **HARRIS TEETER STORE #289 ~ REMODEL**  
2603 GLENWOOD AVENUE, SUITE 101  
RALEIGH, NC 27608  
The: **HVAC DEMOLITION FLOOR PLAN**