


**MEZZANINE PLAN**  
 SCALE: 1/8"=1'-0"

- GENERAL DEMOLITION NOTES:**
- REFER TO ELECTRICAL RENOVATION PLANS AND ARCHITECTURAL FIXTURE PLANS FOR NEW EQUIPMENT LAYOUT AND THE EXTENT OF FIXTURES/EQUIPMENT BEING REPLACED, RELOCATED OR REMOVED.
  - EXISTING CONDITIONS SHOWN ARE BASED ON EXISTING DRAWINGS AND FIELD OBSERVATIONS AND MAY NOT BE COMPLETE OR ALL INCLUSIVE OF THE CIRCUITS OR DEVICES TO BE DEMOLISHED OR RELOCATED. THE ELECTRICAL CONTRACTOR SHALL SURVEY THE EXISTING CONDITIONS TO DETERMINE THE EXTENT OF THE RENOVATION AND DETERMINE WHAT CONDUIT, WIRING, DEVICES, ETC. MAY BE REUSED IN PLACE FOR THE RENOVATION WORK TO BE PERFORMED.
  - EXISTING CONDUIT AND WIRING THAT IS REUSED MUST BE IN GOOD CONDITION AND MEET THE REQUIREMENTS OF THE CIRCUIT OR EQUIPMENT AS SHOWN ON THE RENOVATION PLANS AND PANEL SCHEDULES.
  - WHERE ELECTRICAL DEVICES ARE REMOVED PROVIDE JUNCTION BOXES, CONDUIT AND WIRING AS REQUIRED TO MAINTAIN THE CONTINUITY OF THE CIRCUIT SERVING EQUIPMENT OR DEVICES TO BE REMOVED.
  - WHERE WALL FINISHES ARE TO BE REMOVED, REPAIRED OR REFINISHED, REMOVE ALL ELECTRICAL DEVICES, SWITCHES AND EQUIPMENT AS REQUIRED, INCLUDING SUCH LOCATION WITH THE ARCHITECTURAL PLANS.
- DISPOSE OF DEMOLISHED MATERIALS AS DIRECTED BY THE HTRM. RETURN ANY UNUSED EQUIPMENT TO THE SUPPLIER.

- KEY NOTES:**
- DISCONNECT REFRIGERATED CASE TO ALLOW FOR REPLACEMENT. PRESERVE CIRCUITS AND RECONNECT AS SHOWN ON E3.1.
  - DISCONNECT CASE TO ALLOW FOR CASE REMOVAL. REMOVE CONDUIT AND WIRING BACK TO SOURCE.
  - CIRCUITS ARE EXISTING TO REMAIN AND SHOWN FOR REFERENCE ONLY.
  - DISCONNECT AND RECONNECT EXISTING CASES AS REQUIRED TO ALLOW FOR CASE SHIFT.
  - FIELD IDENTIFY AND DISCONNECT CIRCUIT FROM CHICKEN DISPLAY TO ALLOW FOR REMOVAL OF EQUIPMENT. REMOVE CONDUIT AND WIRING BACK TO SOURCE.
  - DISCONNECT DONUT DISPLAY CASE TO ALLOW FOR REMOVAL OF EQUIPMENT. REMOVE CONDUIT AND WIRING BACK TO SOURCE.
  - FIELD IDENTIFY CIRCUIT SERVING CARVEL CASE TO BE REMOVED. REMOVE ELECTRICAL DEVICE, CONDUIT AND WIRING BACK TO SOURCE.
  - DISCONNECT CIRCUITS SERVING CHECKSTANDS TO BE REMOVED. DEMOLISH EXISTING POWER POLES, REMOVE CIRCUITS TO NEW LOCATIONS SHOWN ON E3.1. REMOVE UNUSED CIRCUITS BACK TO SOURCE.
  - FIELD IDENTIFY CIRCUIT SERVING DRINK COOLER TO BE RELOCATED. RELOCATE CEILING MOUNTED RECEPTACLE AND CORD DROP TO NEW DRINK COOLER LOCATION. EXTEND CONDUIT AND WIRING AS REQUIRED.
  - DISCONNECT AND REMOVE CEILING MOUNTED RECEPTACLE AND CORD DROP (IF PRESENT). REMOVE CONDUIT AND WIRING BACK TO SOURCE. FIELD VERIFY EXACT LOCATIONS OF EXISTING RECEPTABLES.
  - DISCONNECT AND REMOVE GONDOLA SHELVING LIGHTS TO ALLOW FOR SHELVING REMOVAL. REMOVE CIRCUIT, CONDUIT AND WIRING BACK TO SOURCE.
  - DISCONNECT AND REMOVE RECEPTABLES AND CIRCUIT FROM REAR OF REFRIGERATED CASES TO BE REPLACED. PRESERVE WIRING AND RECONNECT TO NEW CASE RECEPTABLES AS SHOWN ON E3.1.
  - DISCONNECT CIRCUITS FROM GAS WATER HEATERS TO BE REMOVED AND REPLACED. PRESERVE CIRCUIT AND RECONNECT TO NEW WATER HEATER AS SHOWN ON E3.1.

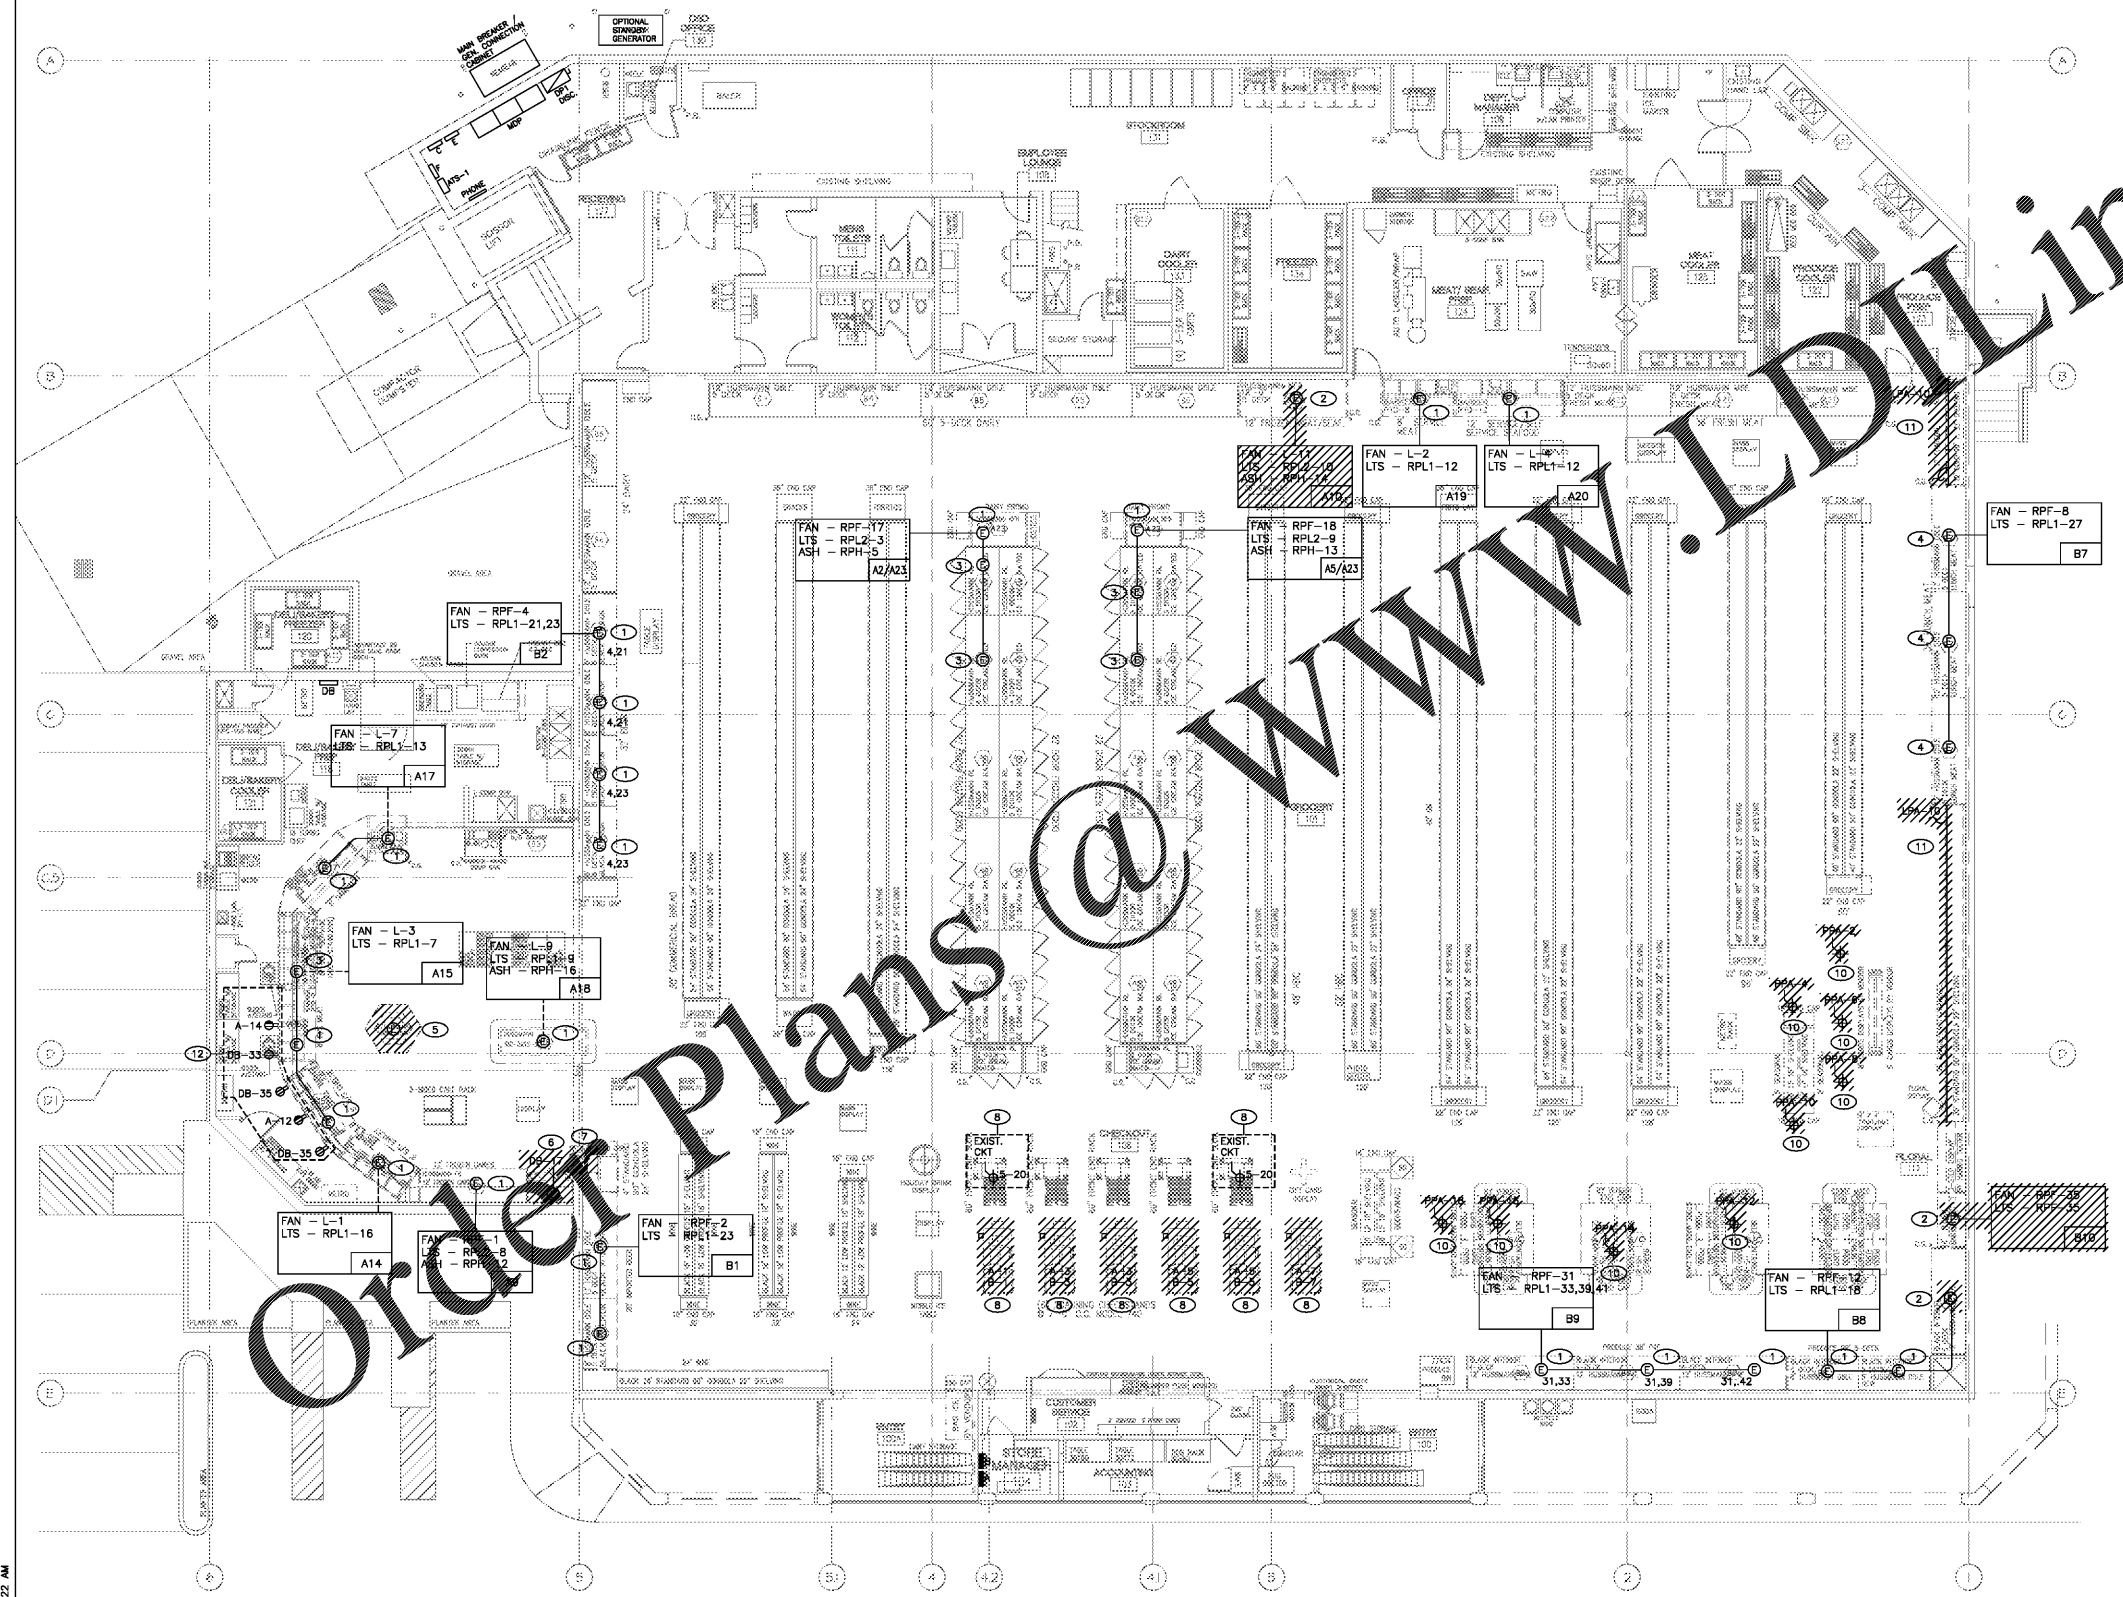

**POWER DEMOLITION PLAN**  
 SCALE: 1/8"=1'-0"



NOTE: THIS DOCUMENT MAY HAVE BEEN ELECTRONICALLY TRANSMITTED. IF UNSIGNED, IT CANNOT BE FILED FOR PUBLIC RECORD. PUBLIC RECORD FILINGS REQUIRE SIGNED AND SEALED DOCUMENTS.

Date: SEPTEMBER 10, 2019 Job No. 1922

Revisions:

No.	Date	By	Check

**BONDURANT ASSOCIATES**  
 ENGINEERING & ARCHITECTURE  
 444 CHAWHORN STREET  
 FORT WORTH, TEXAS

**BRAND ENGINEERING, INC.**  
 NC LICENSE NO. C-1504  
 2840 POLO PARKWAY, SUITE 200  
 FARMINGTON, NC 27834  
 PHONE: (817) 794-8588  
 FAX: (817) 794-8588  
 EMAIL: brand@brandeng.com

**Harris Teeter**  
 Neighborhood Food & Pharmacy

Project: **HARRIS TEETER STORE #289 ~ REMODEL**  
 2603 GLENWOOD AVENUE, SUITE 101  
 RALEIGH, NC 27608

Title: **POWER DEMOLITION PLAN**