 
 
 
 


 
 
 

 








 


RCP LEGEND:
NOTE: SEE FINISH SCHEDULE AT A801


-  24"x24" (ACOUSTICAL CEILING TILE)
-  24"x24" (ACOUSTICAL CEILING TILE) WITH 5/8" FACED SOUND ATTENUATION FIBERGLASS BATT INSULATION (ALL TOILETS and SHOWER STALLS) OTHER THAN DECON TOILET.
-  PAINTED GYPSUM CEILING BOARD & BULKHEAD (3/4" THK.)
-  PAINTED GYPSUM CEILING BOARD (3/4" THK.) WITH 5/8" FACED SOUND ATTENUATION FIBERGLASS BATT INSULATION (ALL BUNK ROOMS)
-  METAL SOFFIT PANEL (MSP), EXTERIOR, SEE A-201
-  CEILING FAN (BUNK ROOMS), SEE ELECTRICAL PLAN
-  CEILING FAN (DAYROOM), SEE ELECTRICAL PLAN
-  EXTERIOR LED WALL PACK
-  EXTERIOR LED WALL SCONCE
-  CEILING HEIGHT TAG (ABOVE FINISH FLOOR)
-  2"x4" LED LIGHT FIXTURE (RECESSED MOUNT)
-  1"x4" LED LIGHT FIXTURE (RECESSED MOUNT)
-  48" LED LIGHT FIXTURE (SUSPENDED for OPEN CEILING)
-  SURFACE MOUNTED UNDER CABINET LED STRIP LIGHT, 36" OR 48" LONG (ALSO IN EMS-108 & LAUNDRY-117)
-  SUSPENDED LED LIGHT PENDANT (DINING-129)
-  RECESSED LED CAN LIGHT (INTERIOR)
-  RECESSED LED CAN LIGHT (EXTERIOR)
-  RECESSED LED WALL WASHER SIGN LIGHT (EXTERIOR)
-  LED WALL PACK (EXTERIOR)

1 HOUR RATED WALL (ALL THE WAY UP TO THE UNDERSIDE OF THE ROOF). PROVIDE CONTINUOUS FIRE CAULKING AROUND THE PERIMETER OF THE WALL & IN ALL OPEN JOINT PENETRATIONS.

 HMS FAN (HIGH VOLUME LOW SPEED FAN) SEE MECHANICAL PLAN FOR SPECS. PROVIDE MOUNTING STEEL BRACKET, SAFETY CABLES, & EXTENSION TUBES AS REQUIRED TO SECURE THE FAN IN PLACE.


RCP NOTES:

1. PROVIDE 5/8" THK. FACED SOUND ATTENUATION BATT INSULATION ABOVE TOILETS/SHOWER AND SLEEP ROOMS CEILING AS INDICATED WITH THIS HATCH.
2. GENERAL CONTRACTOR SHALL COORDINATE THE INSTALLATION AND PROPER LOCATION OF ALL HVAC GRILLES AND LIGHTINGS. CEILING GRID MAYBE SUBJECT TO CHANGE TO ASSURE PROPER CENTERING AND PLACEMENT OF LIGHT FIXTURES IN ROOMS.
3. NO ACT (ACOUSTICAL CEILING TILES) TO BE LESS THAN 4" IN EITHER DIRECTION, UNLESS DIRECTED BY THE ARCHITECT.
4. SEE ADDITIONAL INSULATION NOTES ON SHEET A-003 & A-004.
5. CEILING HEIGHTS ARE DERIVED FROM BASE ELEVATION OF THE FINISH FLOOR = 0'-0" UNLESS NOTED OTHERWISE.
6. VERIFY ALL LIGHT FIXTURES AND LOCATIONS WITH THE ELECTRICAL PLAN.
7. VERIFY ALL DIFFUSER TYPES AND LOCATIONS (SUPPLY & RETURN GRILLES) WITH THE MECHANICAL PLAN.
8. ALL EXTERIOR SOFFIT/OVERHANG SHALL BE OF METAL SOFFIT PANEL (MSP), SEE ROOF PLAN A-103 & A-104 FOR THE ADDITIONAL OVERHANGS AT APPARATUS BAY THAT IS NOT SHOWN ON THIS SHEET.
9. ALL WALL MOUNTED TV'S ARE TO BE BY OWNER. GO TO PROVIDOR WOOD BLOCKING AS REQUIRED. CONFIRM MOUNTING HEIGHTS WITH THE OWNER PRIOR TO INSTALLATION.
10. IN CASE THERE'S A NEED TO ACCESS MECHANICAL TAMPER HANDLES OR OTHER FIRE/PLUMBING CONTROL VALVES IN THE HARD CEILING AREAS, PROVIDE A MINIMUM OF 16"x16" PANEL CEILING ACCESS DOOR.

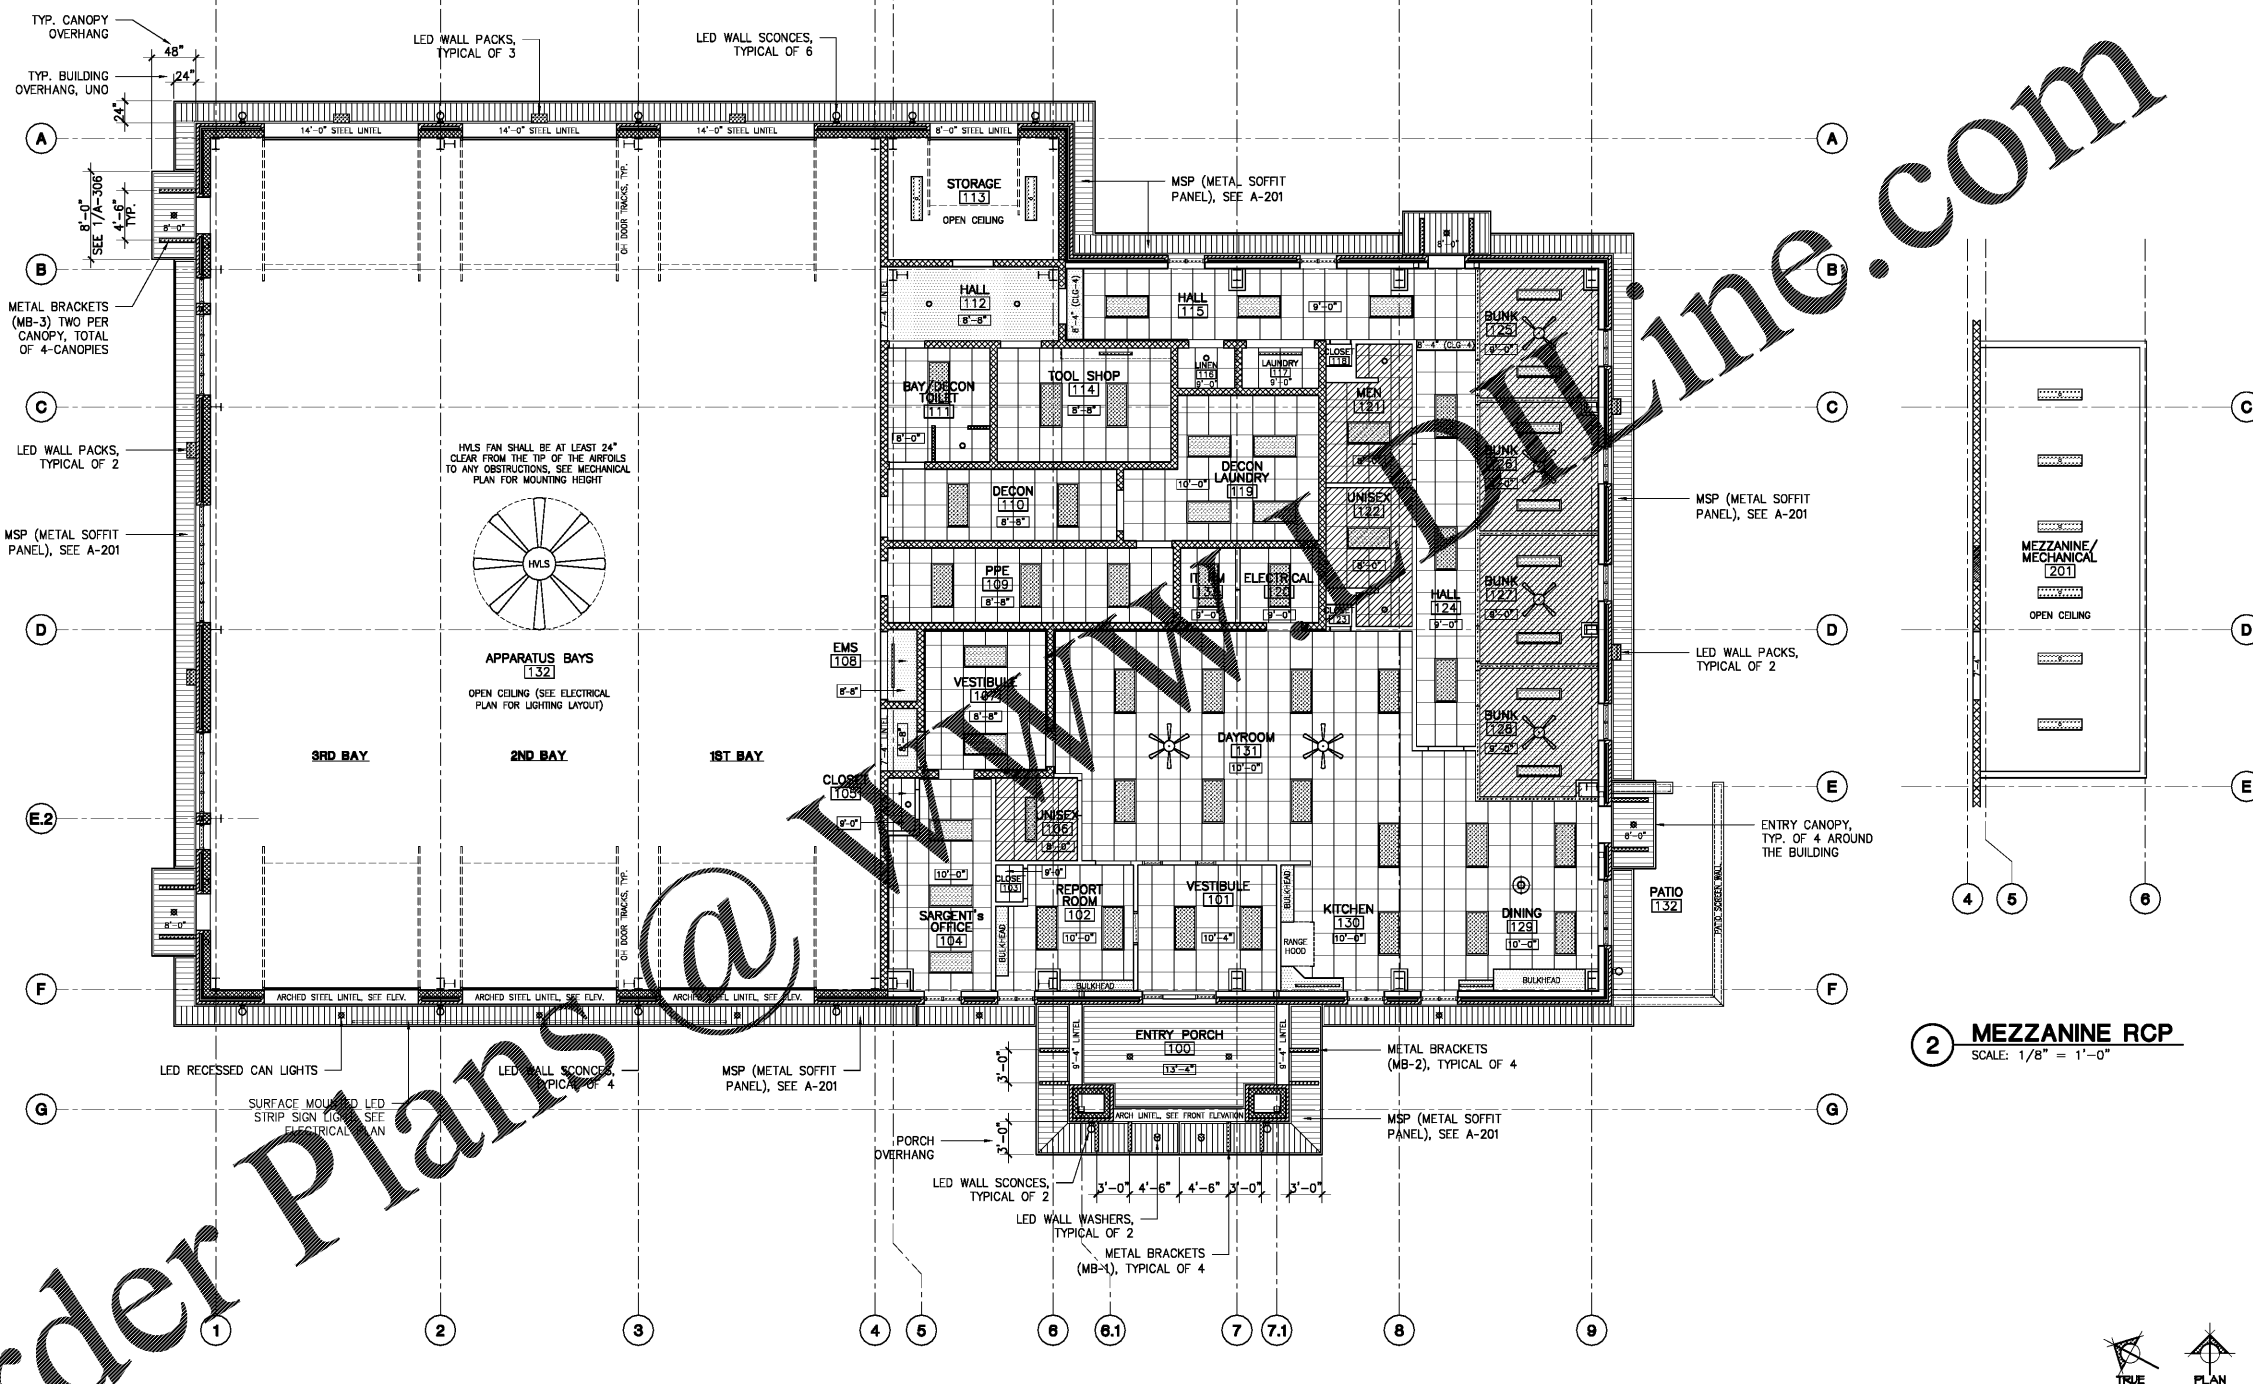

1 REFLECTED CEILING PLAN (RCP)
SCALE: 1/8" = 1'-0"

2 MEZZANINE RCP
SCALE: 1/8" = 1'-0"

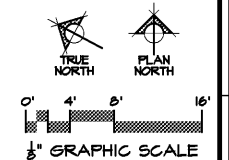

GENERAL NOTES:
ALL NOTES APPLY TO ALL DRAWINGS AND ALL TRADES. IT IS THE RESPONSIBILITY OF ALL CONTRACTORS AND TRADES TO COORDINATE THE INSTALLATION OF THEIR WORK WITH THE INSTALLATION OF WORK BY ALL OTHER CONTRACTORS AND TRADES. THE REQUIREMENTS OF THE DRAWINGS, GENERAL REQUIREMENTS AND ALL ITEMS OF THE CONTRACT DOCUMENTS ARE EQUALLY BINDING ON ALL CONTRACTORS AND TRADES. EACH CONTRACTOR IS REQUIRED TO MAINTAIN FULL SETS OF THE CONTRACT DOCUMENTS FOR HIS EMPLOYEES USE ON THE PROJECT TO ASSURE THAT ALL WORK IS PROPERLY COORDINATED AND INSTALLED WITH THE WORK OF OTHER CONTRACTORS AND TRADES.
WHENEVER THERE ARE DISCREPANCIES BETWEEN DRAWINGS, OR BETWEEN THE DRAWINGS AND SPECIFICATIONS, OR CONFLICTS WITHIN THE SPECIFICATIONS AND/OR DRAWINGS, AND SUCH DISCREPANCY IS NOT CALLED TO THE ARCHITECT'S ATTENTION IN TIME TO PERMIT CLARIFICATION BY ADDENDUM, THE CONTRACTOR SHALL BASE HIS BID UPON PROVIDING THE BETTER QUALITY OR GREATER WORK OR MATERIAL CALLED FOR. SHALL SUBMIT A WRITTEN STATEMENT WITH HIS PROPOSAL NOTING SUCH DISCREPANCIES, AND SHALL SO FURNISH AND INSTALL SUCH BETTER QUALITY OR GREATER QUANTITY UNLESS OTHERWISE ORDERED IN WRITING.

Stewart - Cooper - Newell
Architects
Tel. 704.865.6311
www.scn-architects.com

JJA
Since 1980
Architects • Engineers • Landscape Architects
JOHNSON, LASCHOBER & ASSOCIATES, P.C.
AUGUSTA, GA • MT. PLEASANT, SC
TEL (706) 724-5756 • TEL (843) 619-4656
FAX (706) 724-3955
WWW.THEJLAGROUP.COM

CITY OF NORTH AUGUSTA, SC
100 GEORGIA AVENUE, NORTH AUGUSTA, SC 29841
PROJECT NAME:
**NORTH AUGUSTA
FIRE STATION 1 RELOCATION**
PROJECT LOCATION:
311 W. MARTINTOWN ROAD, NORTH AUGUSTA, SC 29841

STEWART-COOPER-NEWELL ARCHITECTS, P.C.
REGISTERED ARCHITECTS
CERT. NO. C-82008
GASTONIA, NC

KENNETH CHARLES NEWELL
REGISTERED ARCHITECT
GASTONIA, NC
04627
09/28/2020

REV	DATE	BY	KCN	ISSUED FOR	DESCRIPTION
0	10/08/20				

PROJECT NO. 3057.2003 (1676)
DRAWN BY: GYS / GEC
CHECKED BY: KCN
DATE: 10/08/2020
SHEET TITLE:

**REFLECTED
CEILING PLAN,
RCP LEGEND
and NOTES**

SCALE: AS NOTED
DRAWING NO. **A-105**
REV. **0**

This document is the property of Johnson, Laschober & Associates, P.C. The unauthorized reproduction, copying or otherwise use of this document is strictly prohibited and any infringement thereupon may be subject to legal action.