



Since 1980
Architects • Engineers • Landscape Architects
JOHNSON, LASCHOBBER &
ASSOCIATES, P.C.
AUGUSTA, GA • MT. PLEASANT, SC
TEL (706) 724-5756 • TEL (843) 619-4656
FAX (706) 724-3935
WWW.THEJLAGROUP.COM

CLIENT: CITY OF NORTH AUGUSTA, SC
100 GEORGIA AVENUE, NORTH AUGUSTA, SC 29841

PROJECT NAME:

**NORTH AUGUSTA
FIRE STATION 1 RELOCATION**

PROJECT LOCATION:
311 W. MARTINTOWN ROAD, NORTH AUGUSTA, SC 29841



REV	DATE	BY	DESCRIPTION
0	10/08/20	CVW	ISSUED FOR BID

PROJECT NO. 3057.2003
DRAWN BY: WBR
CHECKED BY: CVW
DATE: 10/08/2020

SHEET TITLE:
FIRE PROTECTION PLANS

SCALE: AS NOTED
DRAWING NO. **F-101** REV. **0**


704.865.6311
www.scn-architects.com




Stewart - Cooper - Newell
Architects
704.865.6311
www.scn-architects.com

CONSTRUCTION NOTES:


- ① 6"Ø INCOMING FIRE PROTECTION SERVICE. BFP AND PIV OUTSIDE BUILDING. SEE CIVIL DRAWINGS FOR CONTINUATION.
- ② 6"Ø SERVICE ENTRANCE; 4"Ø RISER (SEE FIRE SPRINKLER RISER SCHEMATIC 1/F-001).
- ③ 4"Ø TO FIRE DEPARTMENT CONNECTION (SEE FIRE SPRINKLER RISER SCHEMATIC 1/F-001).
- ④ 1 1/2"Ø INCOMING POTABLE WATER SERVICE BY PLUMBING CONTRACTOR.

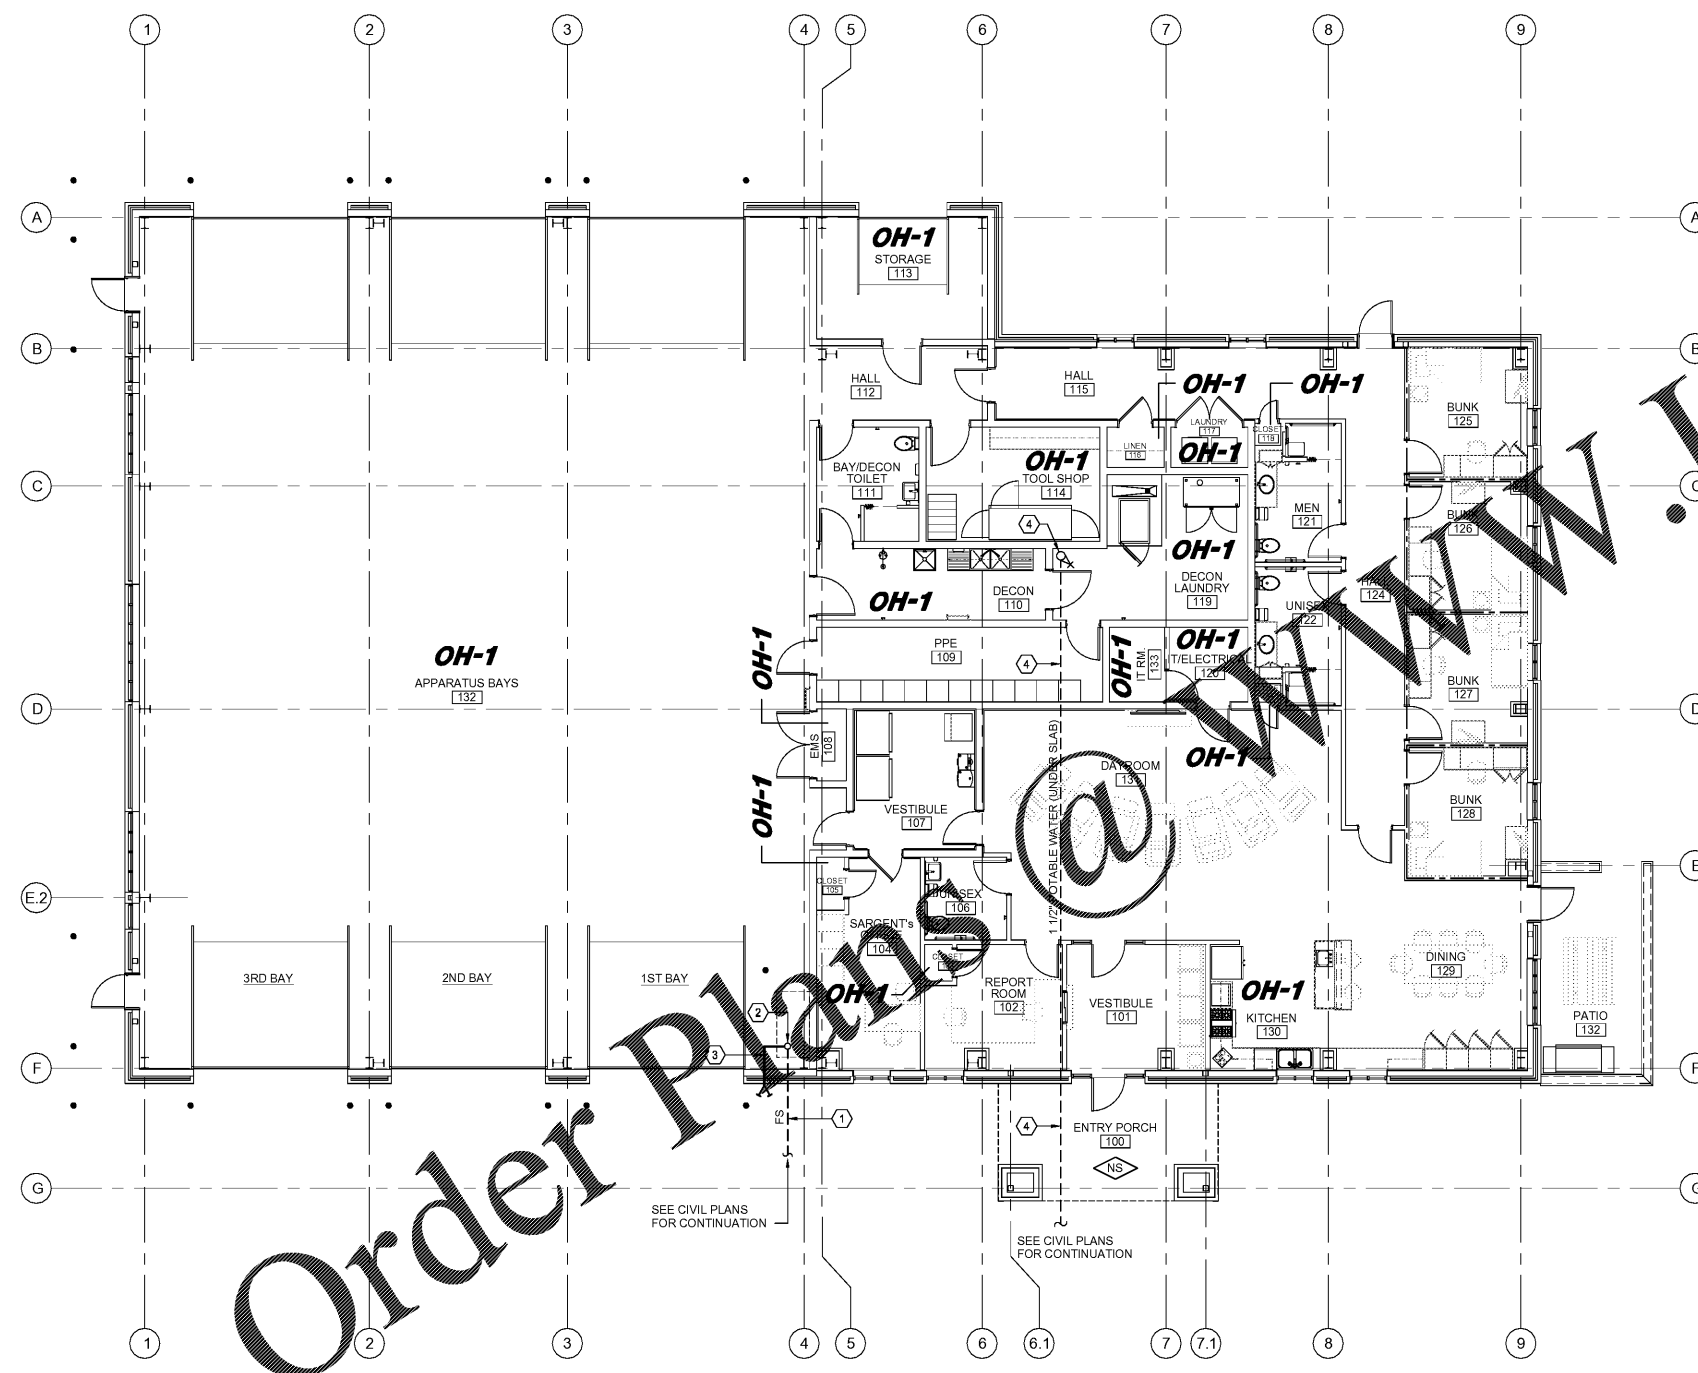

NOTE:
LIGHT HAZARD UNLESS NOTED OTHERWISE.
1 FIRE PROTECTION PLAN
F-101 SCALE: 1/8" = 1'-0"

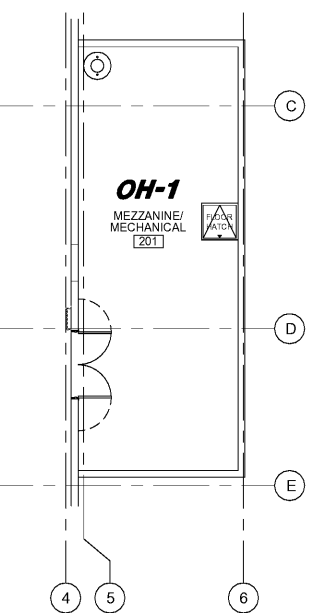

NOTE:
LIGHT HAZARD UNLESS NOTED OTHERWISE.
2 MEZZANINE FIRE PROTECTION PLAN
F-102 SCALE: 1/8" = 1'-0"

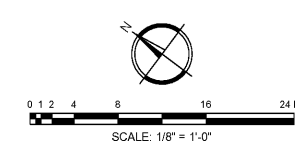

Order Plans @ www.LDILine.com

This document is the property of Johnson, Laschober & Associates, P.C. The unauthorized reproduction, copying or otherwise use of this document is strictly prohibited and any infringement thereupon may be subject to legal action.