


LIGHTING PLAN CONSTRUCTION NOTES:

1. OCCUPANCY SENSOR SWITCHES IN SLEEPING ROOMS SHALL BE PLACED IN VACANCY MODE.



LIGHTING PLAN KEYED NOTES:

- 1 PROVIDE PHOTOCELL AND TIME CLOCK TO CONTROL EXTERIOR LIGHTS.
- 2 PROVIDE DUAL LITE LG250 LIGHTING INVERTER FOR EACH BAY EMERGENCY LIGHT.

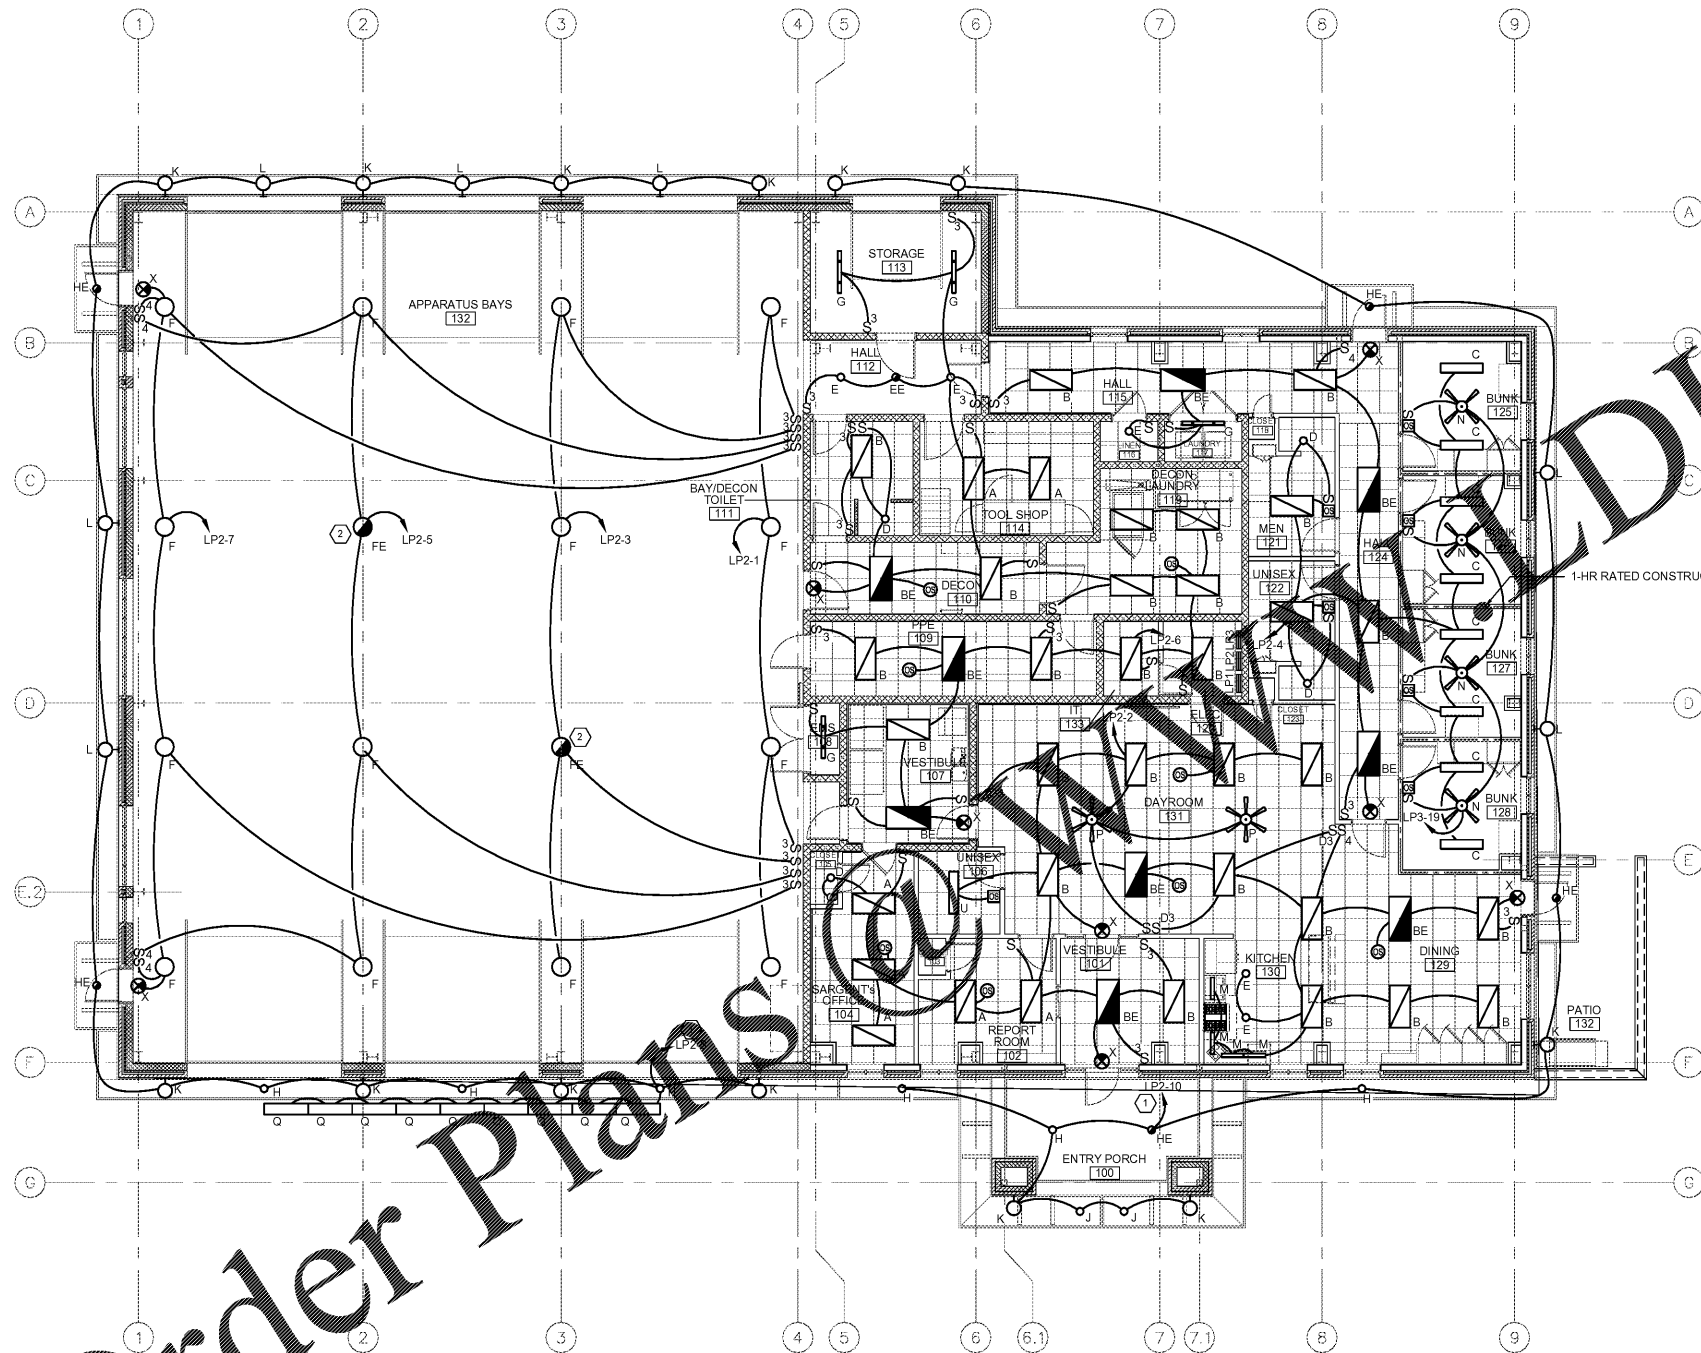

1 LIGHTING PLAN
E-101 SCALE: 1/8" = 1'-0"

2 MEZZANINE LIGHTING PLAN
E-101 SCALE: 1/8" = 1'-0"

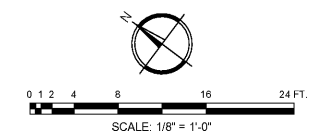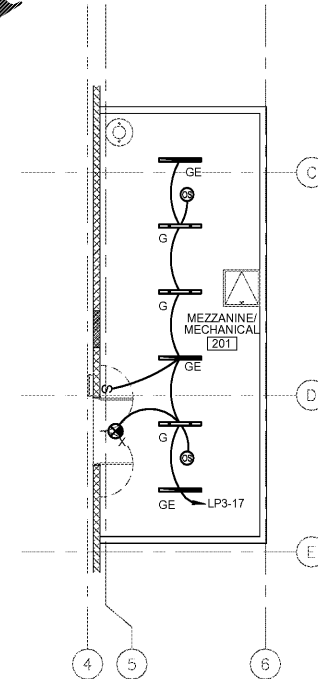

Stewart-Cooper-Newell
Architects
704.865.6311
www.scn-architects.com

Since 1980
Architects • Engineers • Landscape Architects
JOHNSON, LASCHOBER &
ASSOCIATES, P.C.
AUGUSTA, GA • MT. PLEASANT, SC
TEL (706) 724-5756 • TEL (843) 619-4656
FAX (706) 724-3935
WWW.THEJLAGROUP.COM

CLIENT: CITY OF NORTH AUGUSTA, SC
100 GEORGIA AVENUE, NORTH AUGUSTA, SC 29841
PROJECT NAME: NORTH AUGUSTA
FIRE STATION 1 RELOCATION
PROJECT LOCATION: 311 W. MARTINTOWN ROAD, NORTH AUGUSTA, SC 29841



REV	DATE	BY	DESCRIPTION
0	10/08/20	HJW	ISSUED FOR PERMIT

PROJECT NO. 3057.2003
DRAWN BY: JAP
CHECKED BY: HJW
DATE: 10/08/2020

SHEET TITLE:
LIGHTING PLANS

SCALE: AS NOTED
DRAWING NO. **E-101** REV. **0**

Order Plans @ www.diline.com