


05-25-20 Sheet: D:\DWG\19\191510000\_FGA\_CPA Fire Station 17\Plumbing\19039\_P1\_1\_SITE\_PLN.dwg

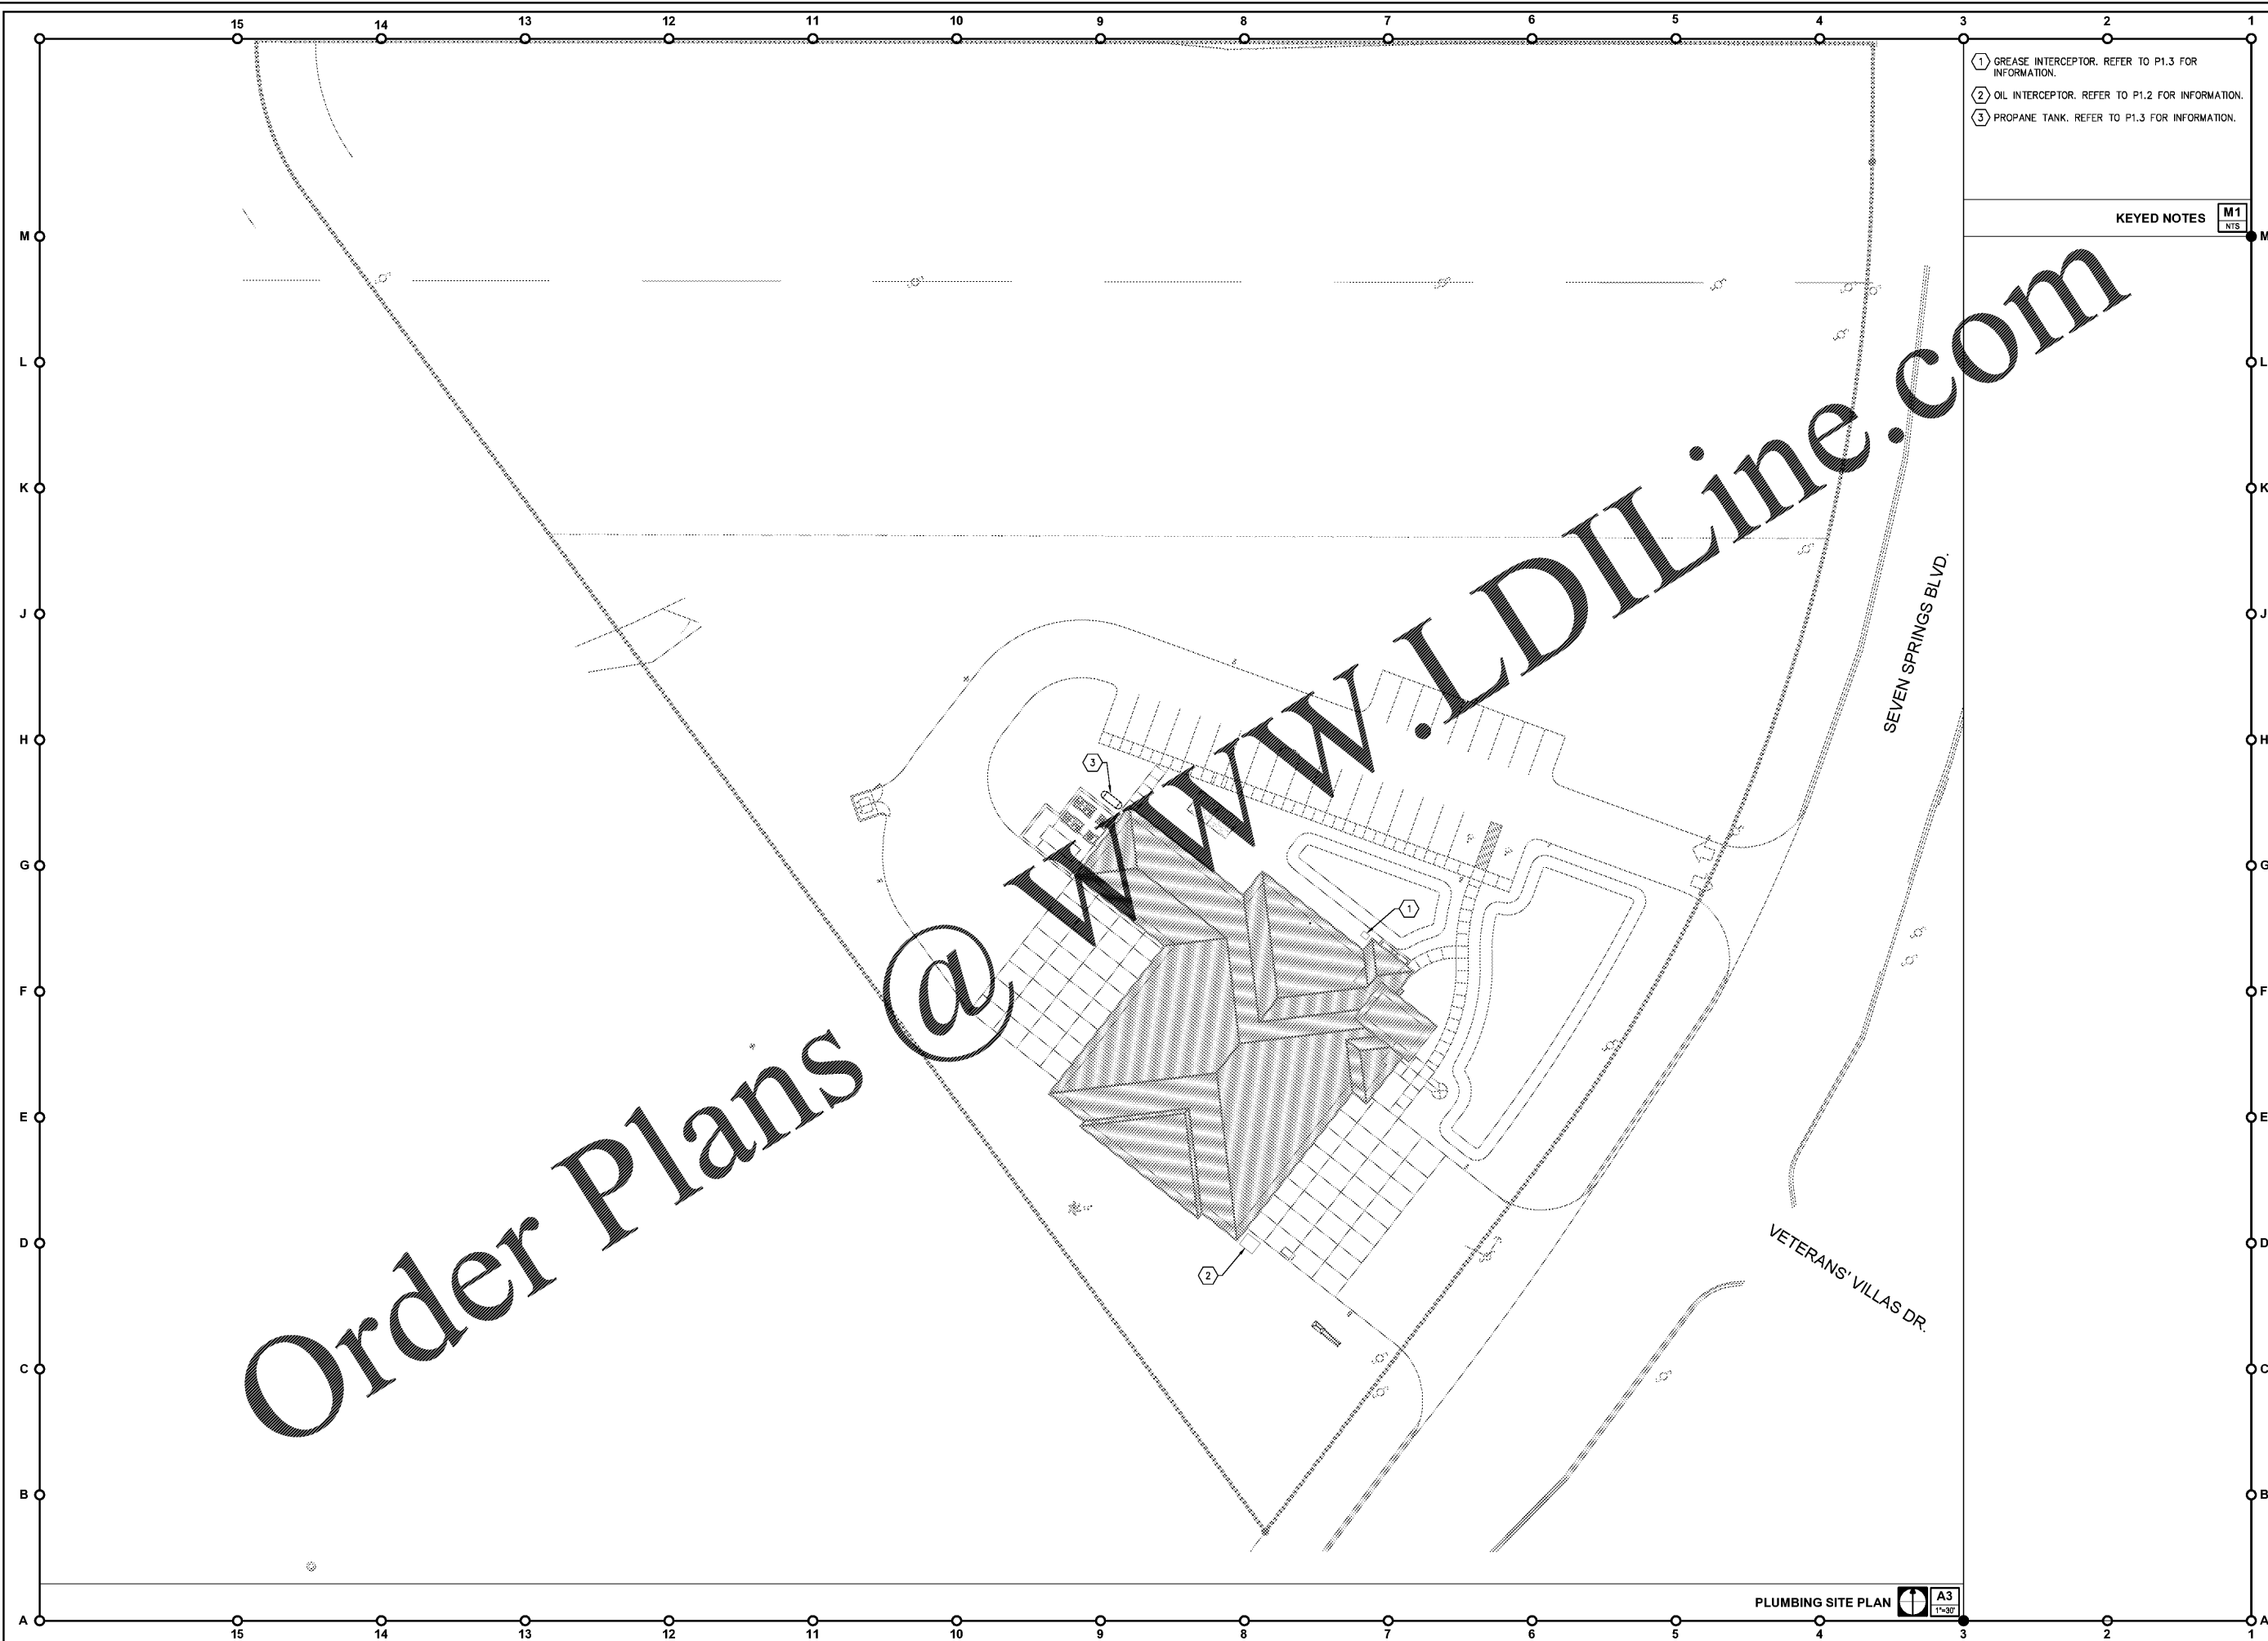

Order Plans @

- 1 GREASE INTERCEPTOR. REFER TO P1.3 FOR INFORMATION.
- 2 OIL INTERCEPTOR. REFER TO P1.2 FOR INFORMATION.
- 3 PROPANE TANK. REFER TO P1.3 FOR INFORMATION.

KEYED NOTES M1 NTS

PLUMBING SITE PLAN A3 1"=30'

**ENGINEERING MATRIX, INC.**  
 CONSULTING ENGINEERS  
 2880 SCHERER DRIVE, SUITE 640  
 ST. PETERSBURG, FLORIDA 33716  
 (727) 372-4668 FAX (727) 571-8062 EMAIL: em@matrixeng.com  
 CERT. OF AUTHORIZATION NO. 42898 P.E. JOB NO. 19-0980  
 © 2019 Engineering Matrix, Inc. DRAWN BY: SCD CHECKED BY: JSW

**FleischmanGarcia**  
 ARCHITECTS • ENGINEERS • INTERIORS DESIGNERS  
 3511 15TH AVENUE NORTH, SUITE 300  
 ST. PETERSBURG, FLORIDA 33716  
 PHONE: (727) 726-8800 FAX: (727) 726-8800  
 REGISTRATION NUMBER: AA 000272

**Pasco County  
 Fire & Rescue Station  
 No. 17**  
 New Port Richey, Florida

THIS PERSON AND DRAWING IS THE SOLE PROPERTY OF FLEISCHMAN-GARCIA AND SHALL NOT BE REPRODUCED OR TRANSMITTED IN ANY FORM OR BY ANY MEANS, ELECTRONIC OR MECHANICAL, WITHOUT THE WRITTEN PERMISSION OF FLEISCHMAN-GARCIA.

LETTER TO THE BEST OF MY KNOWLEDGE THAT THESE DRAWINGS COMPLY WITH ALL RELEVANT BUILDING CODES.

FGA PROJECT NUMBER 19039

ISSUE DATE 05-25-20

REVISIONS	
△	DATE: _____
△	DATE: _____
△	DATE: _____
△	DATE: _____

SHEET NUMBER P1.1