


05-25-20 Sheet D:\dwg\10\dwg\10\10-0000 FGA Fire Station 17\10\dwg\10-0000\_P2\_1\_THRU\_P2\_4\_P1\_ANS.dwg

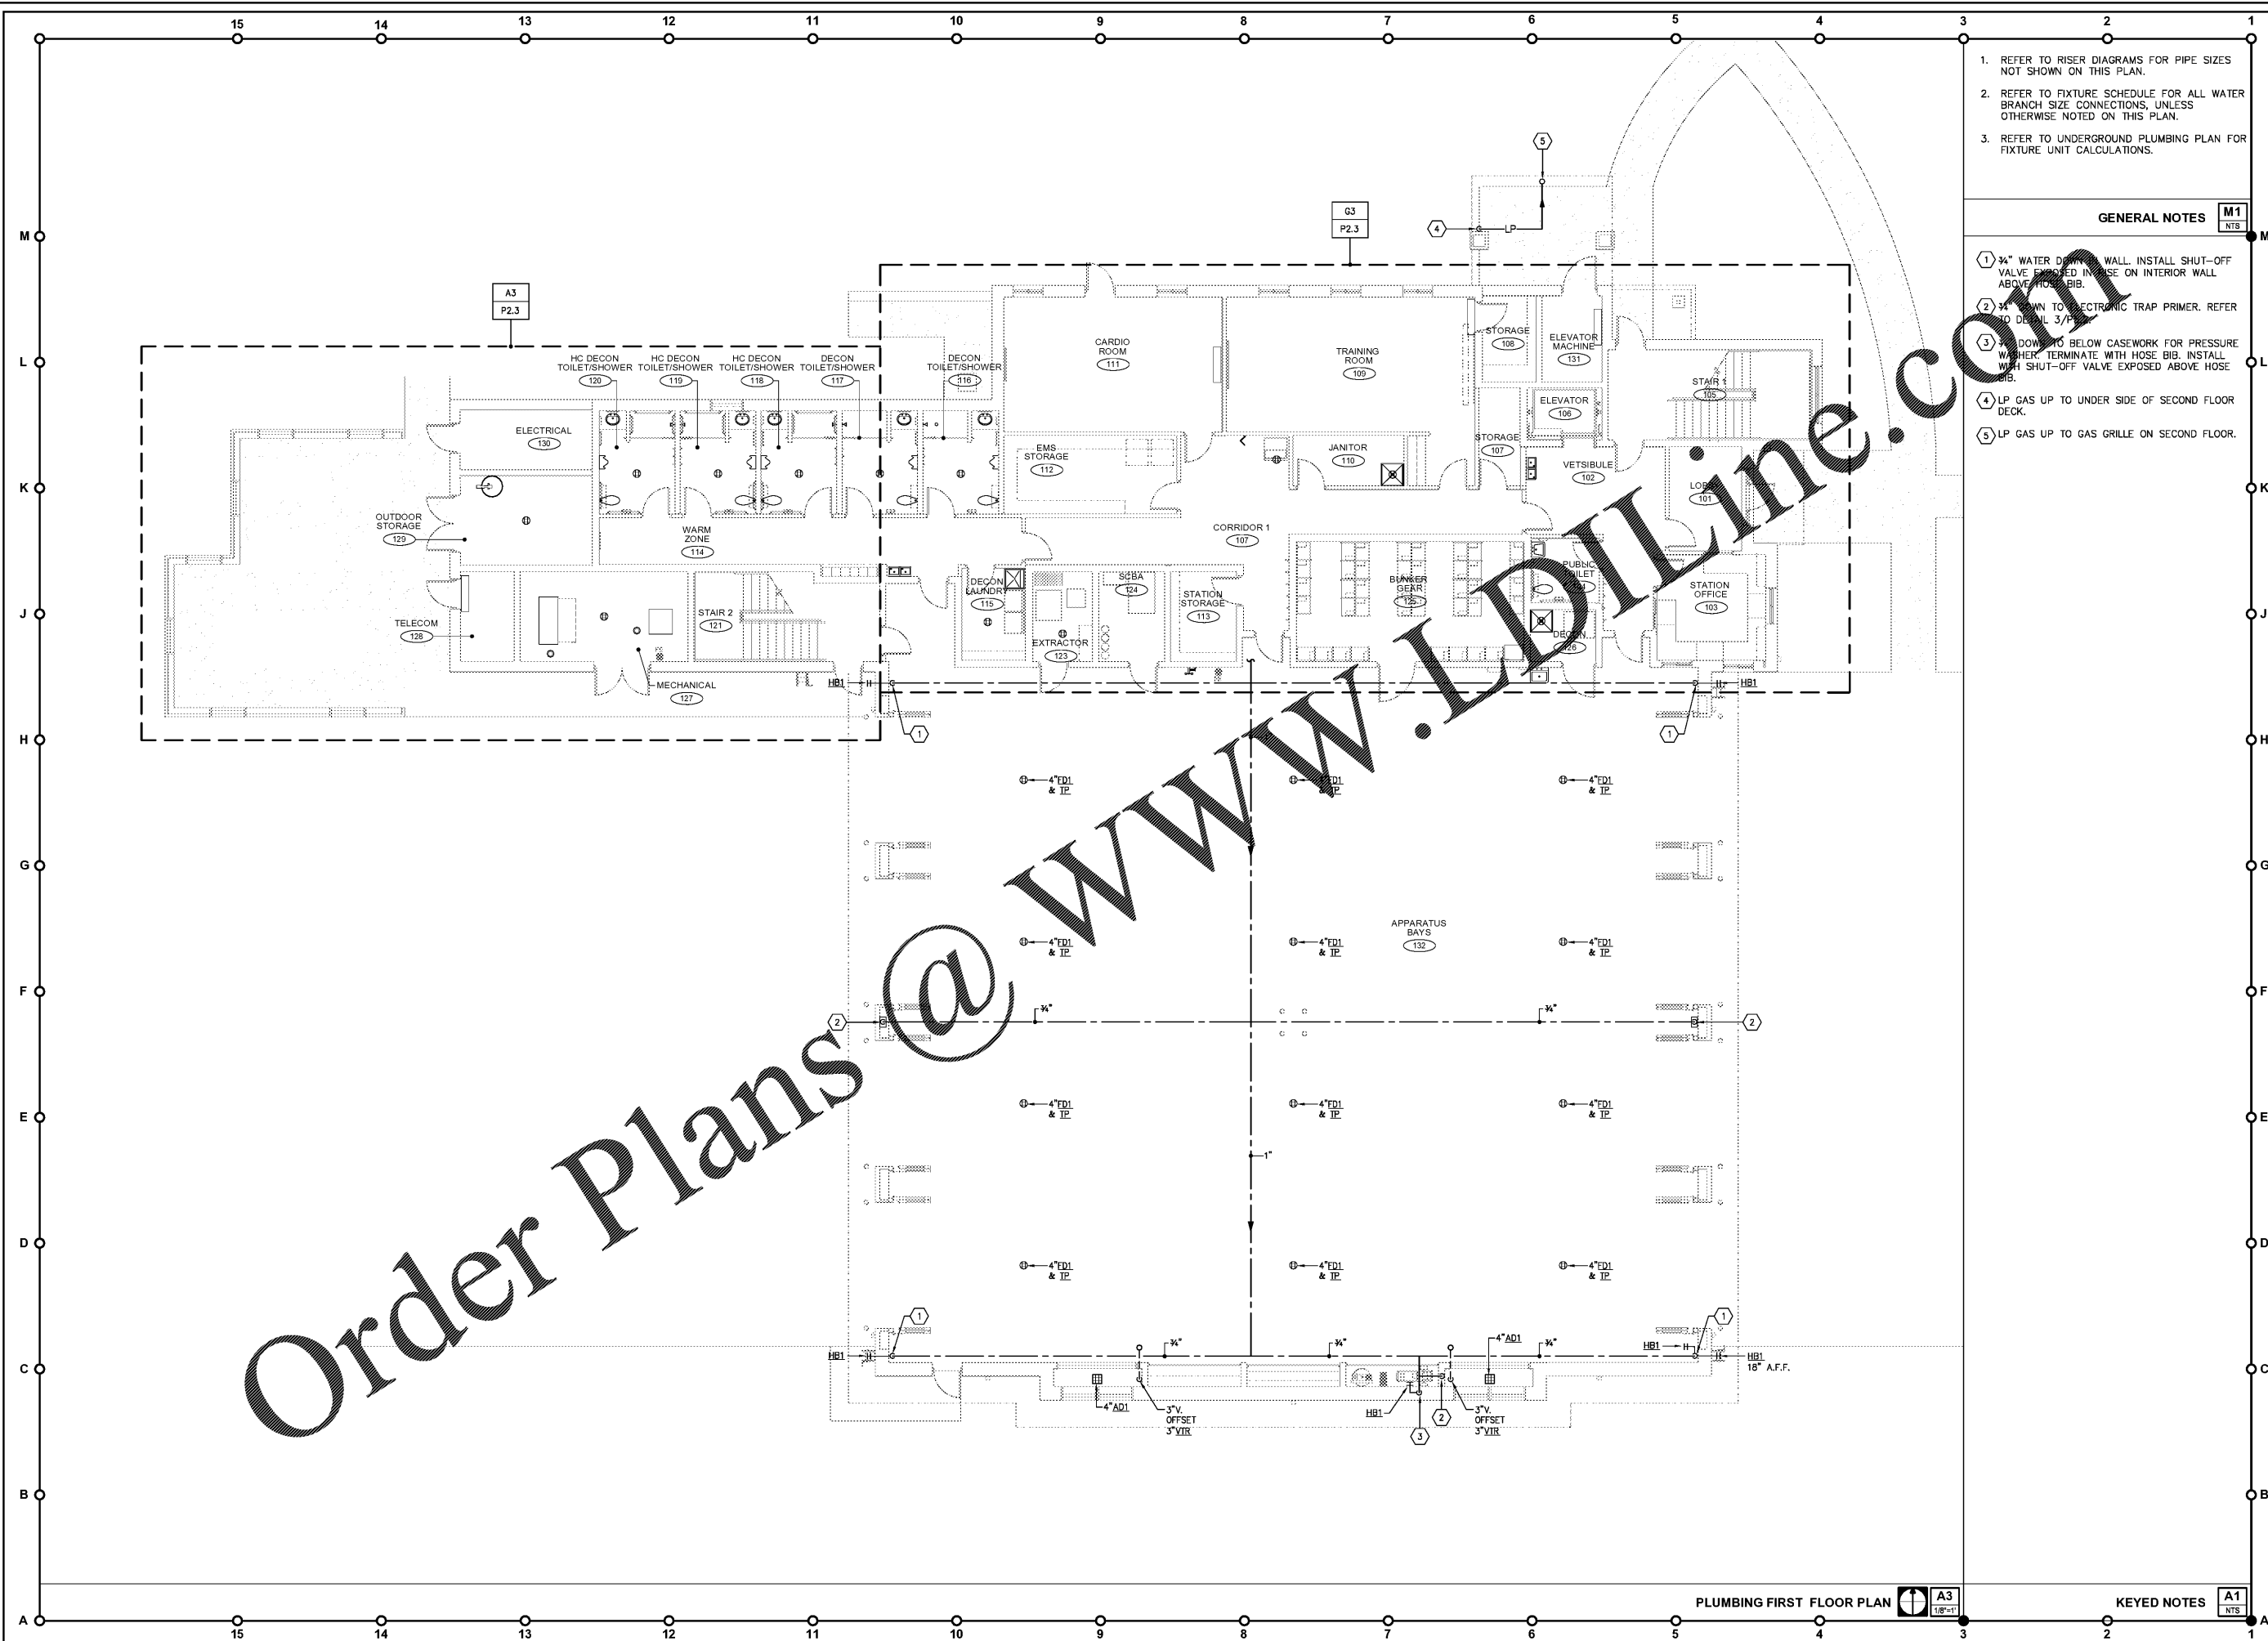

Order Plans @ [www.1010line.com](http://www.1010line.com)

1. REFER TO RISER DIAGRAMS FOR PIPE SIZES NOT SHOWN ON THIS PLAN.
2. REFER TO FIXTURE SCHEDULE FOR ALL WATER BRANCH SIZE CONNECTIONS, UNLESS OTHERWISE NOTED ON THIS PLAN.
3. REFER TO UNDERGROUND PLUMBING PLAN FOR FIXTURE UNIT CALCULATIONS.

**GENERAL NOTES**

1. 3/4" WATER DOWN WALL. INSTALL SHUT-OFF VALVE EXPOSED IN INTERIOR WALL ABOVE HOSE BIB.
2. 1/2" DOWN TO ELECTRIC TRAP PRIMER. REFER TO DETAIL 3/4" TRAP.
3. 1/2" DOWN TO BELOW CASEWORK FOR PRESSURE WASHER. TERMINATE WITH HOSE BIB. INSTALL WITH SHUT-OFF VALVE EXPOSED ABOVE HOSE BIB.
4. LP GAS UP TO UNDER SIDE OF SECOND FLOOR DECK.
5. LP GAS UP TO GAS GRILLE ON SECOND FLOOR.

**ENGINEERING MATRIX, INC.**  
 CONSULTING ENGINEERS  
 2800 SCHREIBER DRIVE, SUITE 640  
 ST. PETERSBURG, FLORIDA 33716  
 (727) 375-4666 FAX (727) 375-3006 EMAIL: [enr@matrixinc.com](mailto:enr@matrixinc.com)  
 CERT. OF AUTHORIZATION NO. 4898 E.M. JOB NO. 19-0900  
 © 2019 Engineering Matrix, Inc. DRAWN BY: XXX CHECKED BY: JSW

**FleischmanGarcia**  
 ARCHITECTS • INTERIORS DESIGNERS  
 3511 15TH AVENUE NORTH, SUITE 300  
 ST. PETERSBURG, FLORIDA 33716  
 PHONE (727) 726-8800 FAX (727) 726-8800  
 REGISTRATION NUMBER: AA 000273

**Pasco County Fire & Rescue Station No. 17**  
 New Port Richey, Florida

THIS PERSON AND DRAWING IS THE SOLE PROPERTY OF FLEISCHMAN-GARCIA ARCHITECTS AND INTERIORS. NO PART OF THIS WORK MAY BE REPRODUCED WITHOUT THE WRITTEN PERMISSION OF FLEISCHMAN-GARCIA ARCHITECTS AND INTERIORS. ANY REUSE OF THIS WORK WITHOUT THE WRITTEN PERMISSION OF FLEISCHMAN-GARCIA ARCHITECTS AND INTERIORS IS STRICTLY PROHIBITED.

FGA PROJECT NUMBER  
**19039**

ISSUE DATE  
**05-25-20**

REVISIONS	
△	DATE: _____
△	DATE: _____
△	DATE: _____

SHEET NUMBER  
**P2.1**

PLUMBING FIRST FLOOR PLAN A3 1/8"=1'

KEYED NOTES A1 NTS