

**ENGINEERING MATRIX, INC.**  
 CONSULTING ENGINEERS  
 2800 SCHEERER DRIVE, SUITE 640  
 ST. PETERSBURG, FLORIDA 33716  
 (727) 321-4668 FAX (727) 571-8062 EMAIL: em@matrixinc.com  
 CERT. OF AUTHORIZATION NO. 42898 P.E. JOB NO. 19-0900  
 © 2019 Engineering Matrix, Inc. DRAWN BY: SCD CHECKED BY: JSW

**FleischmanGarcia**  
 ENGINEERING ARCHITECTURE INTERIORS  
 3501 WINDY PARK AVENUE, SUITE 300  
 TAMPA, FLORIDA 33629  
 PHONE (813) 721-4400  
 FAX (813) 721-5206  
 REGISTRATION NUMBER: AA 000217

**Pasco County  
 Fire & Rescue Station  
 No. 17**  
 New Port Richey, Florida


THIS DESIGN AND DRAWING IS THE SOLE PROPERTY OF FLEISCHMAN-GARCIA AND SHALL BE REPRODUCED WITHOUT PERMISSION FROM FLEISCHMAN-GARCIA.  
 I CERTIFY TO THE BEST OF MY KNOWLEDGE THAT THESE DRAWINGS COMPLY WITH ALL RELEVANT BUILDING CODES.

FGA PROJECT NUMBER  
**19039**

ISSUE DATE  
**05-25-20**

REVISIONS  
 △ DATE: \_\_\_\_\_  
 △ DATE: \_\_\_\_\_  
 △ DATE: \_\_\_\_\_

SHEET NUMBER  
**P3.1**

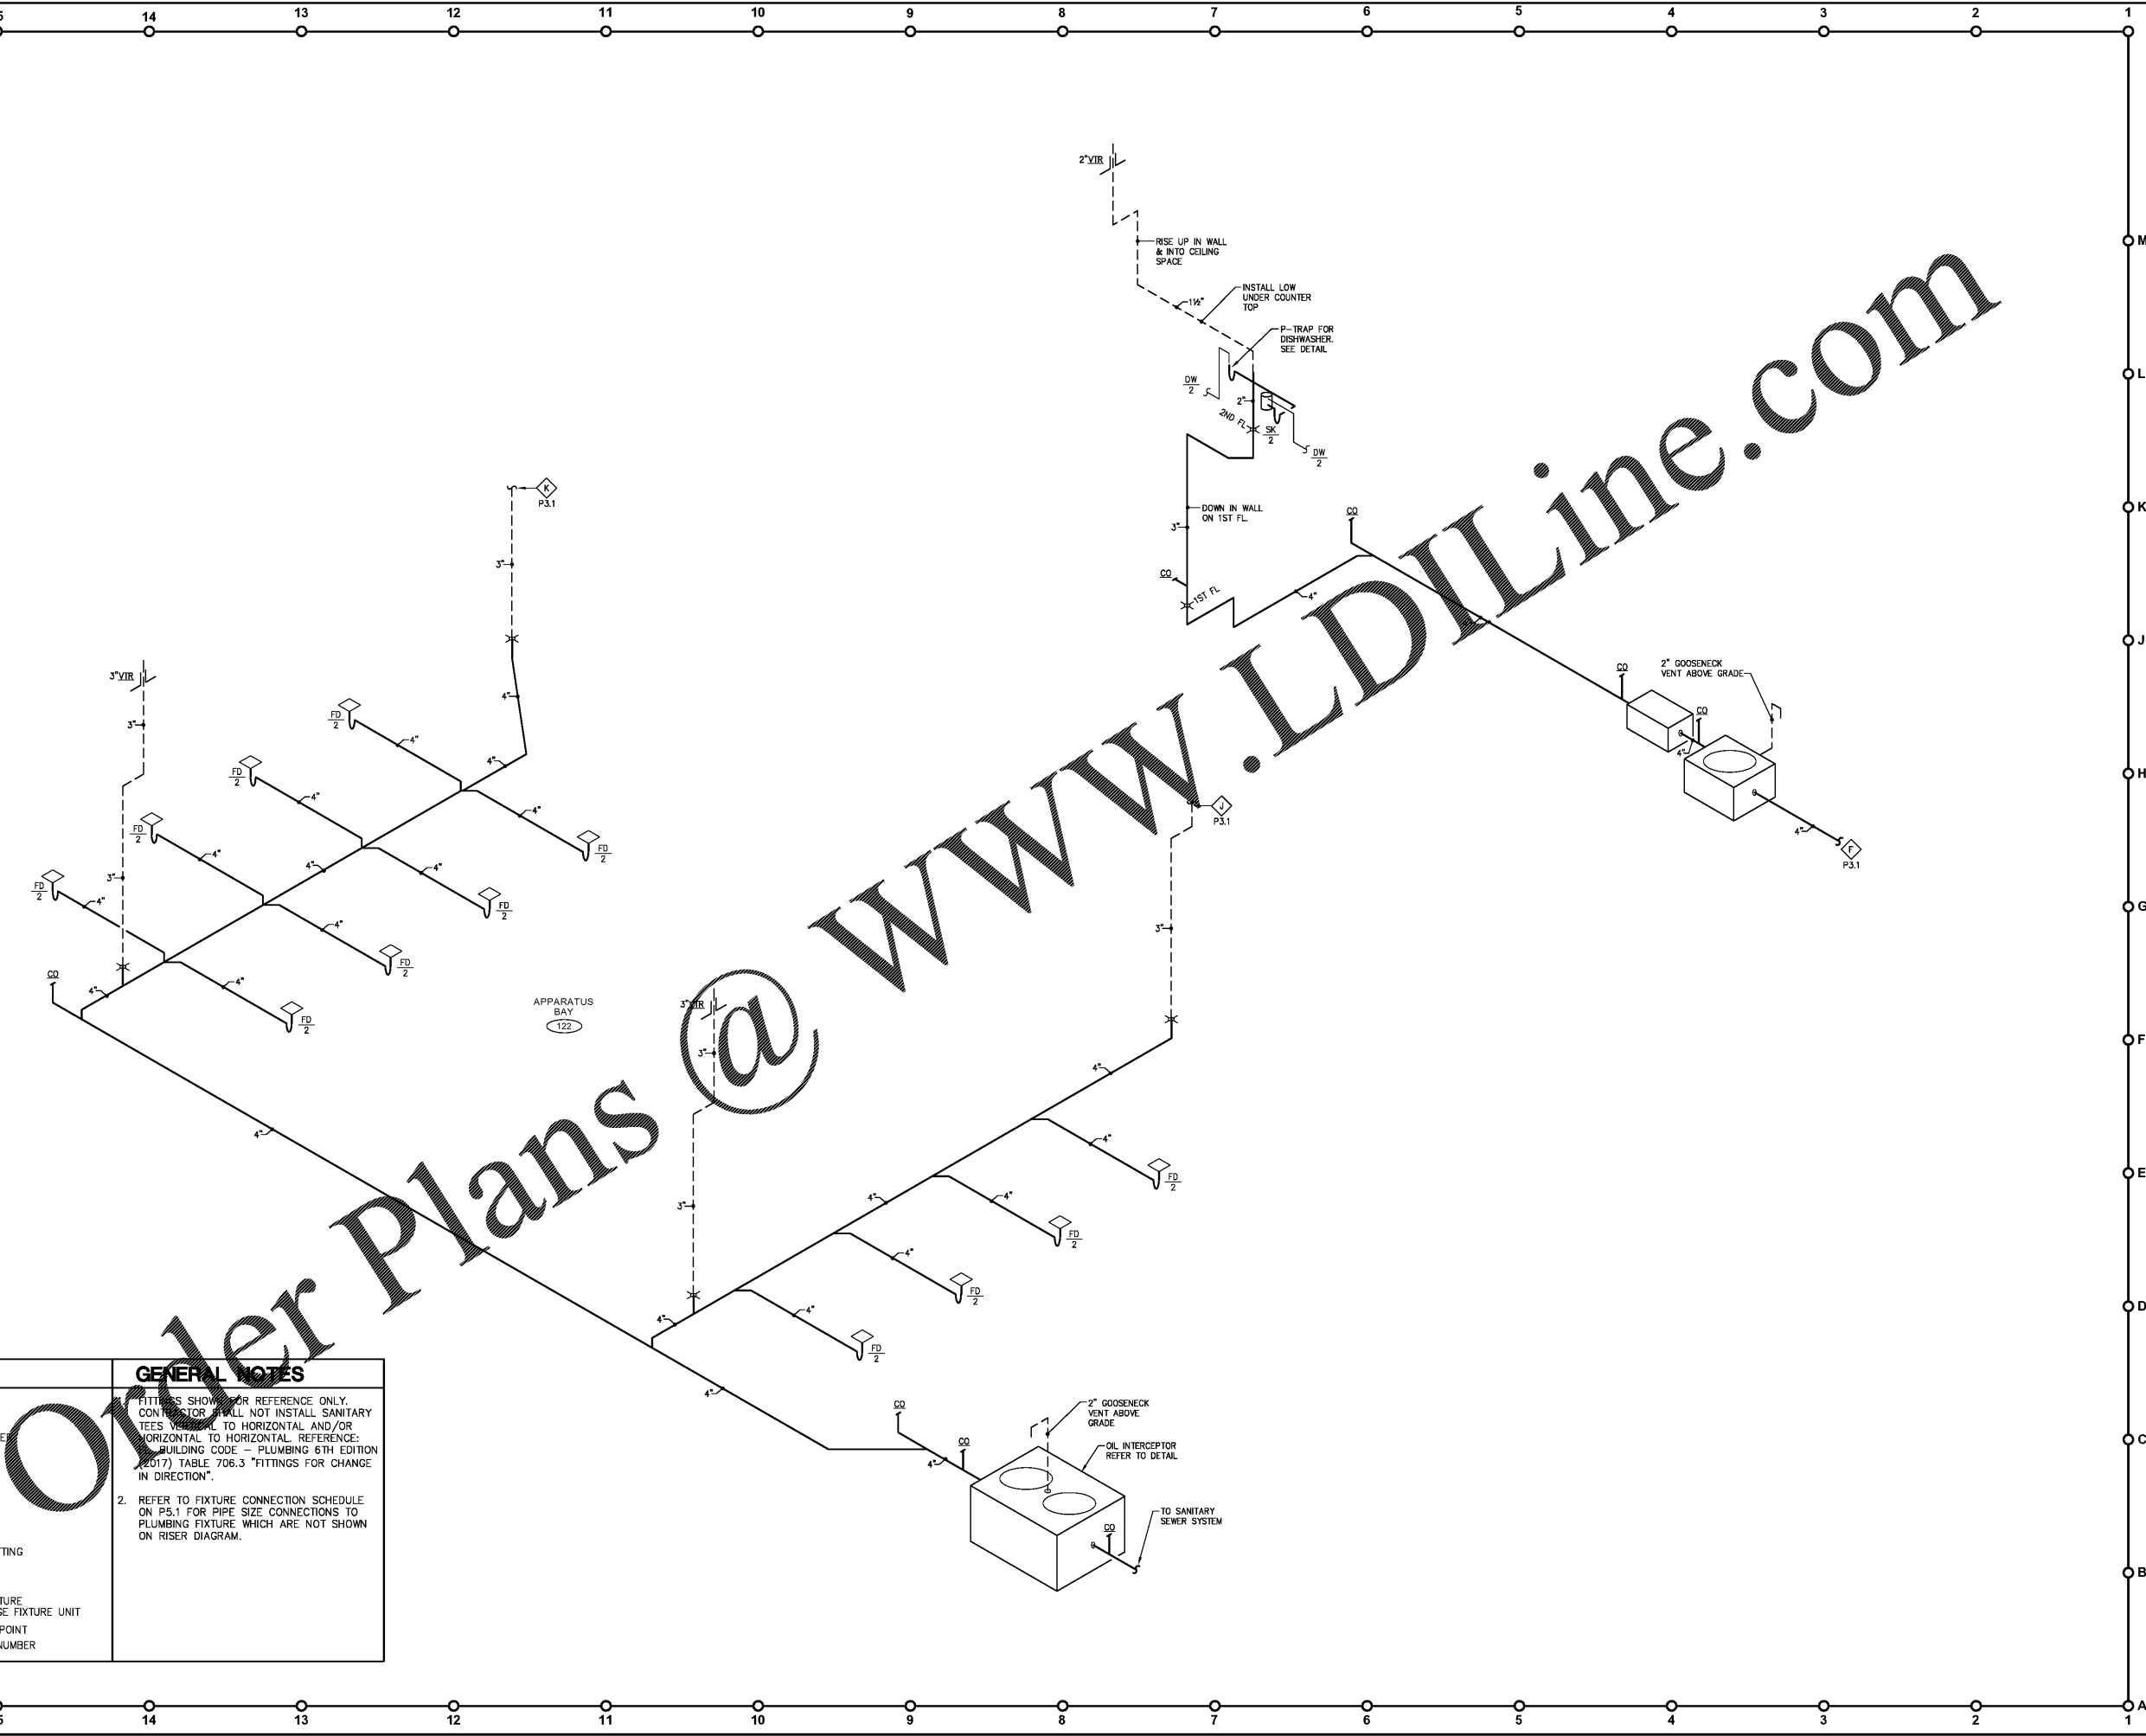

LEGEND	GENERAL NOTES
ABBREVIATIONS: DW: DISHWASHER EWC: ELECTRIC WATER COOLER FD: FLOOR DRAIN FS: FLOOR SINK LAV: LAVATORY SH: SHOWER SK: SINK SS: SERVICE SINK UR: URINAL WMF: WASHING MACHINE FITTING WC: WATER CLOSET VTR: VENT THROUGH ROOF  4" → PIPE SIZE OR FIXTURE 17 → DENOTES DRAINAGE FIXTURE UNIT ◇ → DENOTES MATCH POINT S1 → DENOTES SHEET NUMBER	FITTINGS SHOWN FOR REFERENCE ONLY. CONTINUOUS SHALL NOT INSTALL SANITARY TEES VERTICAL TO HORIZONTAL AND/OR HORIZONTAL TO HORIZONTAL. REFERENCE: BUILDING CODE - PLUMBING 6TH EDITION (2017) TABLE 706.3 "FITTINGS FOR CHANGE IN DIRECTION". 2. REFER TO FIXTURE CONNECTION SCHEDULE ON P5.1 FOR PIPE SIZE CONNECTIONS TO PLUMBING FIXTURE WHICH ARE NOT SHOWN ON RISER DIAGRAM.

www.LDILine.com  
 Over Plans @

05-25-20 S:\new\19039\19039-FGA-CFA-Fire Station 17\19039-FGA-CFA-Fire Station 17\19039-FGA-CFA-Fire Station 17\_P3\_2\_RBS\FRS.dwg