


05-25-20 10:00 AM 10/18/2019 10:00 AM FGA, CPA, P.E. Station 17700/10/18/2019-0000_P3_L_P3_2_ISSUES.dwg

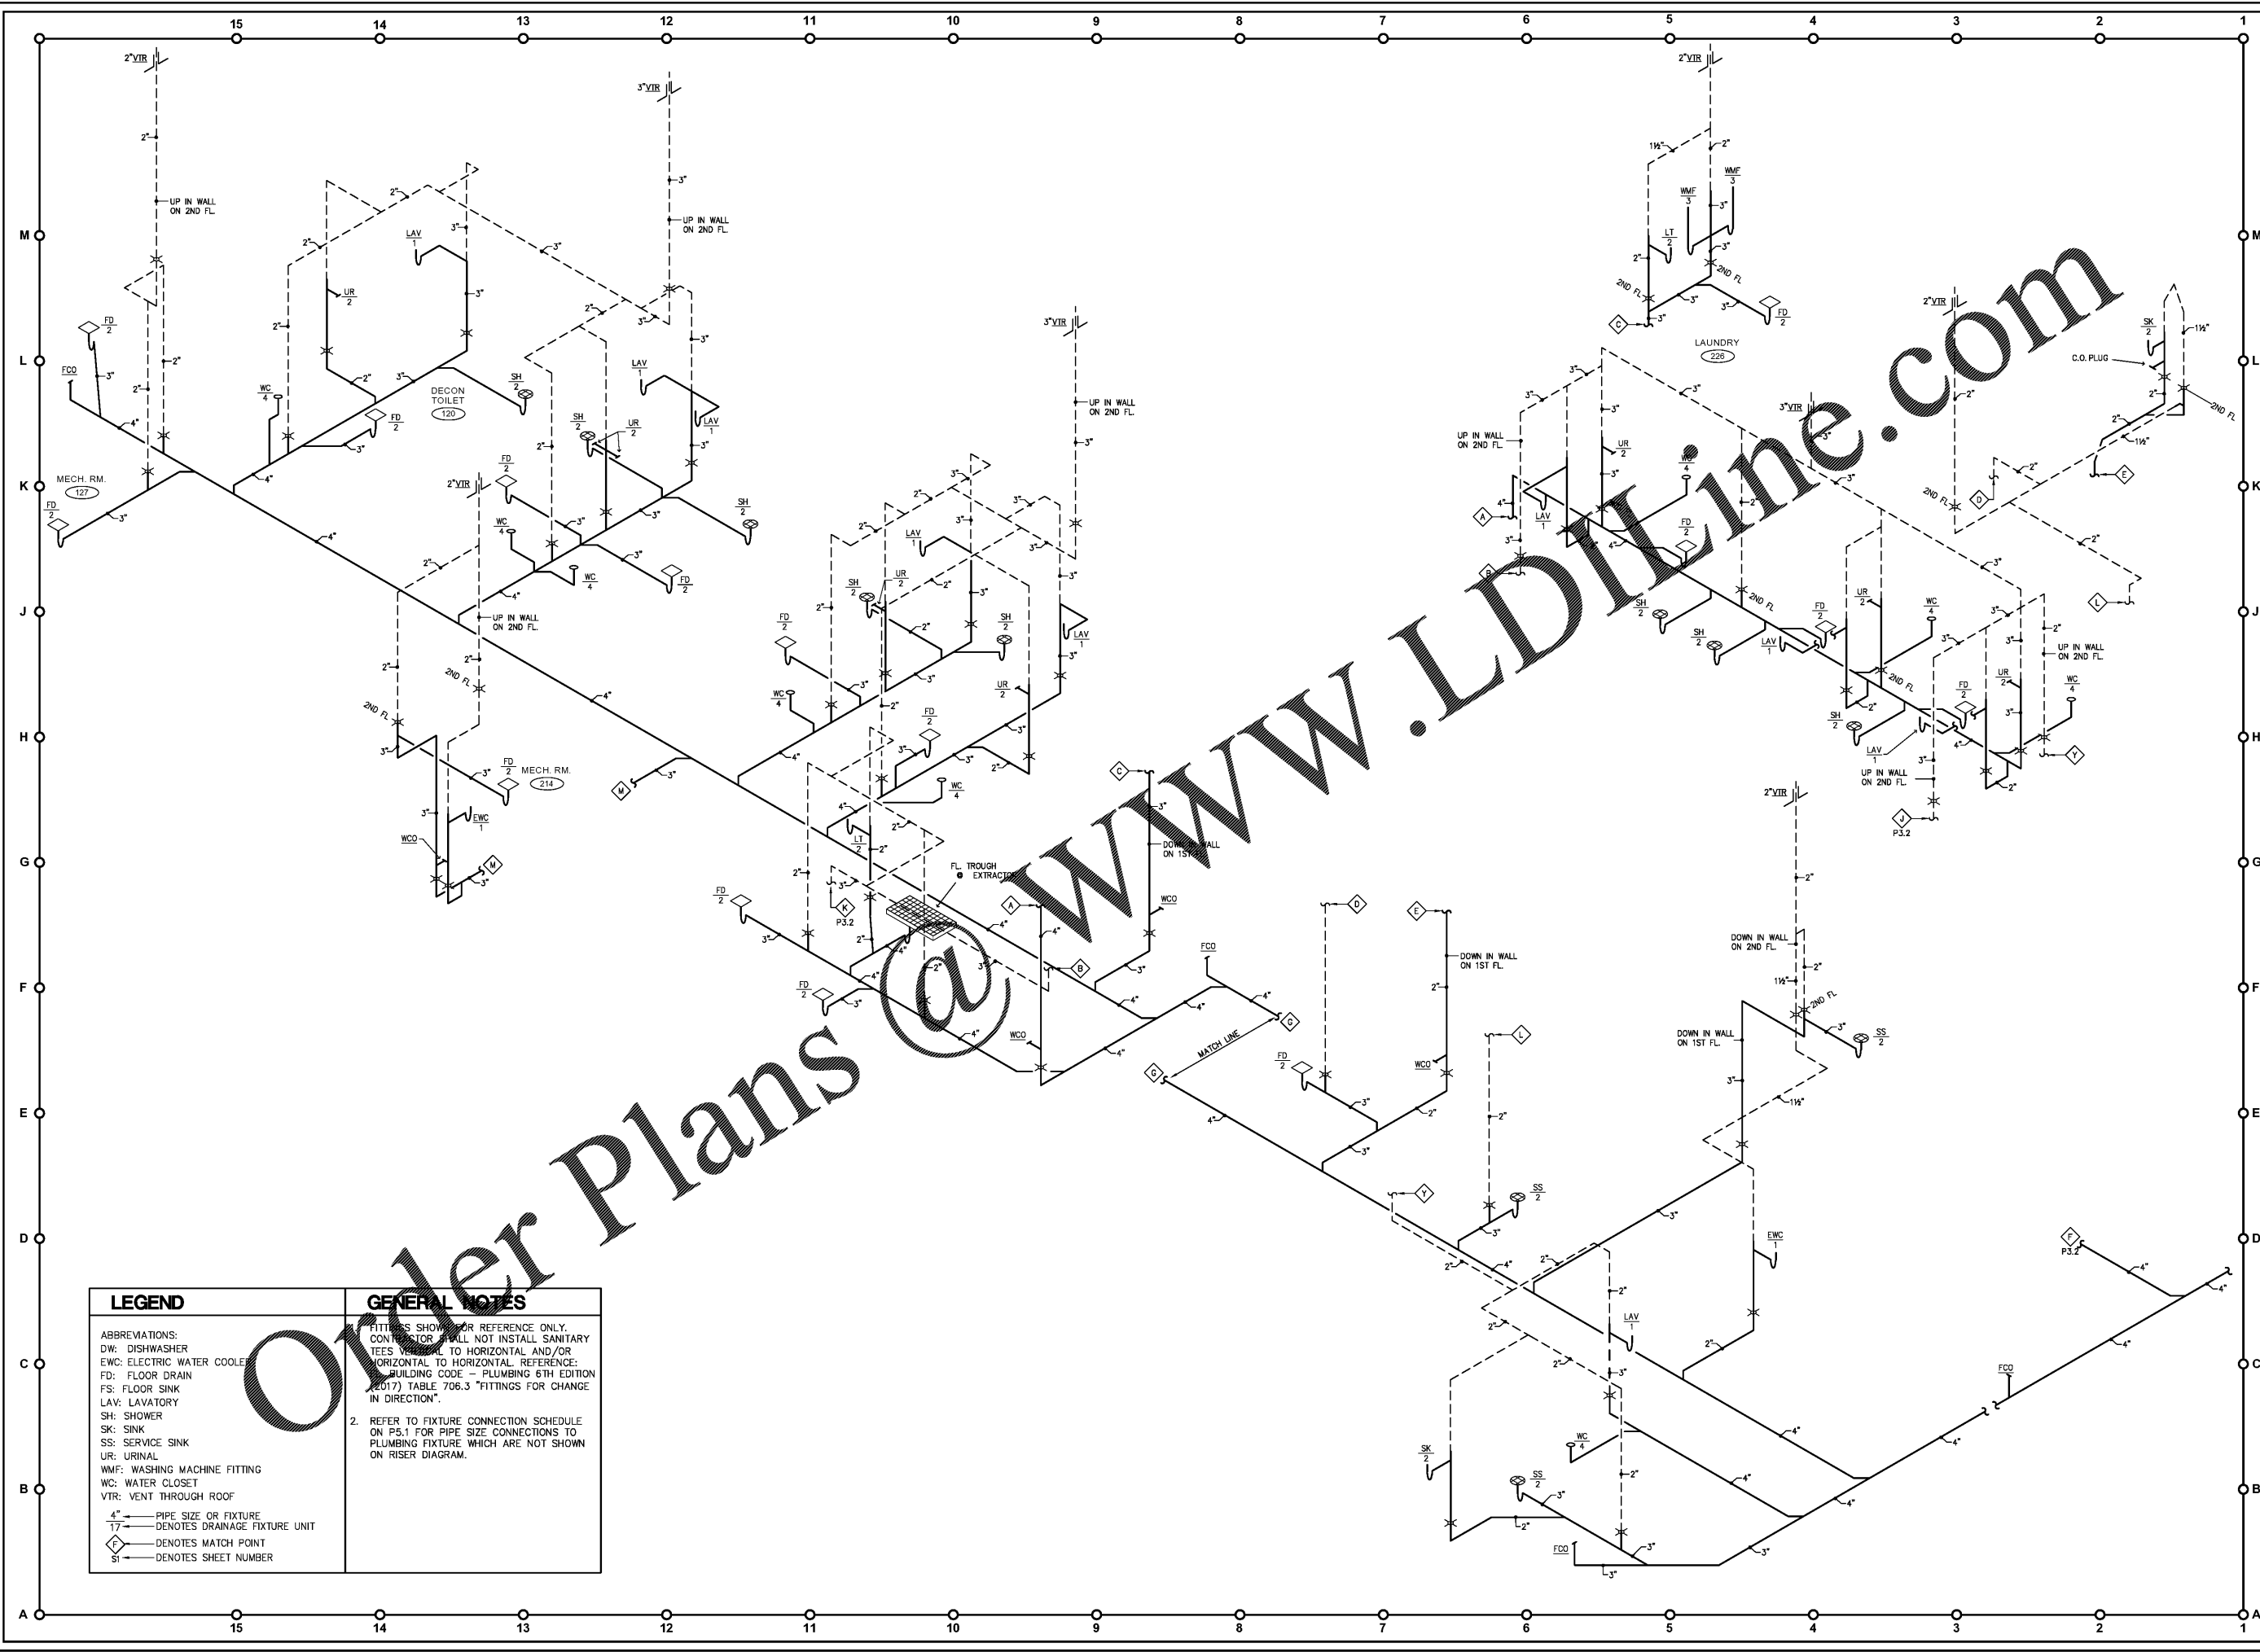

LEGEND	GENERAL NOTES
<p>ABBREVIATIONS:</p> <p>DW: DISHWASHER</p> <p>EWC: ELECTRIC WATER COOLER</p> <p>FD: FLOOR DRAIN</p> <p>FS: FLOOR SINK</p> <p>LAV: LAVATORY</p> <p>SH: SHOWER</p> <p>SK: SINK</p> <p>SS: SERVICE SINK</p> <p>UR: URINAL</p> <p>WMF: WASHING MACHINE FITTING</p> <p>WC: WATER CLOSET</p> <p>VTR: VENT THROUGH ROOF</p> <p>4" — PIPE SIZE OR FIXTURE</p> <p>17 — DENOTES DRAINAGE FIXTURE UNIT</p> <p>◇ — DENOTES MATCH POINT</p> <p>S1 — DENOTES SHEET NUMBER</p>	<p>FITTINGS SHOWN FOR REFERENCE ONLY. CONTRACTOR SHALL NOT INSTALL SANITARY TEES VERTICAL TO HORIZONTAL AND/OR HORIZONTAL TO HORIZONTAL. REFERENCE: BUILDING CODE - PLUMBING 6TH EDITION (2017) TABLE 706.3 "FITTINGS FOR CHANGE IN DIRECTION".</p> <p>2. REFER TO FIXTURE CONNECTION SCHEDULE ON P5.1 FOR PIPE SIZE CONNECTIONS TO PLUMBING FIXTURE WHICH ARE NOT SHOWN ON RISER DIAGRAM.</p>

ENGINEERING MATRIX, INC.
 CONSULTING ENGINEERS
 2880 SCHEERER DRIVE, SUITE 640
 ST. PETERSBURG, FLORIDA, 33716
 (727) 321-4666 FAX (727) 571-8062 EMAIL: em@matrixeng.com
 CERT. OF AUTHORIZATION NO. 4898 E.M. JOB NO. 19-0960
 © 2019 Engineering Matrix, Inc. DRAWN BY: SCD CHECKED BY: JSW

FleischmanGarcia
 ARCHITECTS • INTERIORS • ENVIRONMENTAL DESIGNERS
 2501 W. PARK AVENUE, SUITE 300
 TAMPA, FLORIDA 33606
 PHONE (813) 281-4000
 FAX (813) 281-2000
 REGISTRATION NUMBER: AA 000272

**Pasco County
 Fire & Rescue Station
 No. 17**
 New Port Richey, Florida

THIS DESIGN AND DRAWING IS THE SOLE PROPERTY OF FLEISCHMAN-GARCIA ARCHITECTS AND SHALL NOT BE REPRODUCED, COPIED, OR TRANSMITTED IN ANY FORM OR BY ANY MEANS WITHOUT THE WRITTEN PERMISSION OF FLEISCHMAN-GARCIA ARCHITECTS.

FGA PROJECT NUMBER
19039

ISSUE DATE
05-25-20

REVISIONS
 △ DATE: _____
 △ DATE: _____
 △ DATE: _____

SHEET NUMBER
P3.2