


05/25/20  
Joanna Wicks\2019151006P FGA CPA Fire Station 17\Bldg\15-0862\_E3\_1\_E3\_2\_Power-POWER.dwg

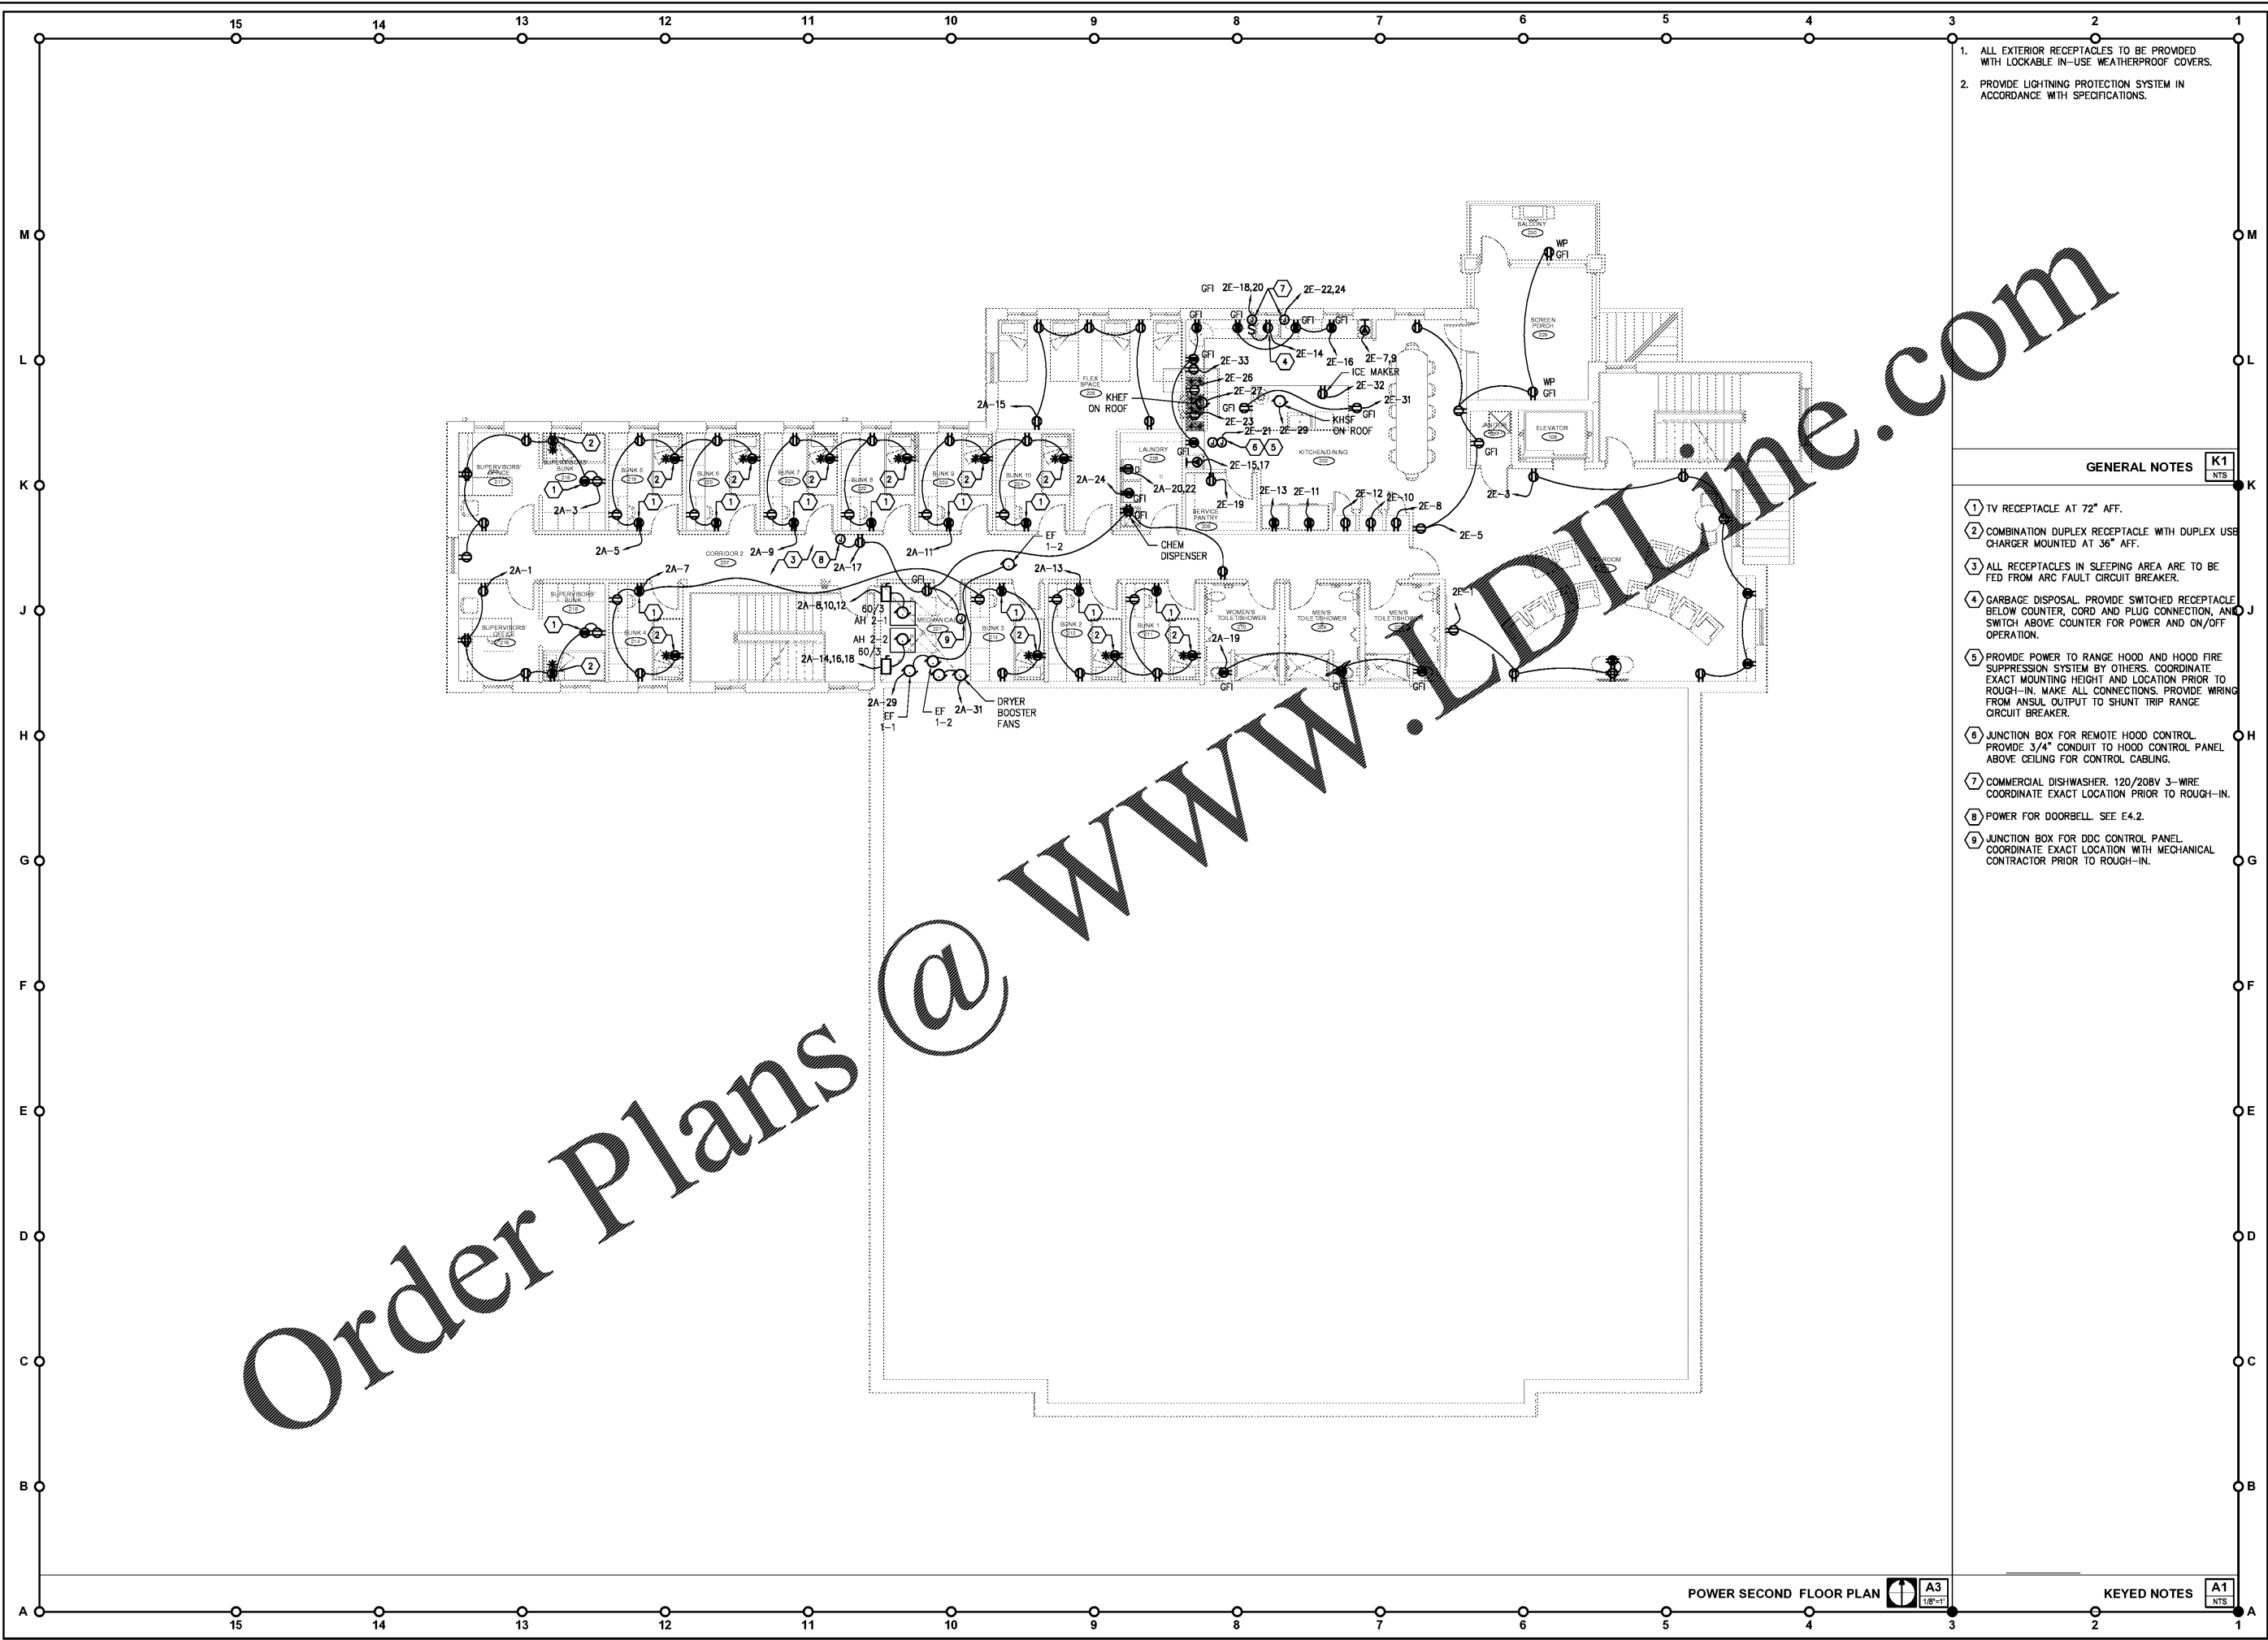

1. ALL EXTERIOR RECEPTACLES TO BE PROVIDED WITH LOCKABLE IN-USE WEATHERPROOF COVERS.
2. PROVIDE LIGHTNING PROTECTION SYSTEM IN ACCORDANCE WITH SPECIFICATIONS.

**GENERAL NOTES** K1  
NTS

- 1 TV RECEPTACLE AT 72" AFF.
- 2 COMBINATION DUPLEX RECEPTACLE WITH DUPLEX USE CHARGER MOUNTED AT 36" AFF.
- 3 ALL RECEPTACLES IN SLEEPING AREA ARE TO BE FED FROM ARC FAULT CIRCUIT BREAKER.
- 4 GARBAGE DISPOSAL. PROVIDE SWITCHED RECEPTACLE BELOW COUNTER, CORD AND PLUG CONNECTION, AND SWITCH ABOVE COUNTER FOR POWER AND ON/OFF OPERATION.
- 5 PROVIDE POWER TO RANGE HOOD AND HOOD FIRE SUPPRESSION SYSTEM BY OTHERS. COORDINATE EXACT MOUNTING HEIGHT AND LOCATION PRIOR TO ROUGH-IN. MAKE ALL CONNECTIONS. PROVIDE WIRING FROM ANSLU OUTPUT TO SHUNT TRIP RANGE CIRCUIT BREAKER.
- 6 JUNCTION BOX FOR REMOTE HOOD CONTROL. PROVIDE 3/4" CONDUIT TO HOOD CONTROL PANEL ABOVE CEILING FOR CONTROL CABLING.
- 7 COMMERCIAL DISHWASHER. 120/208V 3-WIRE. COORDINATE EXACT LOCATION PRIOR TO ROUGH-IN.
- 8 POWER FOR DOORBELL. SEE E4.2.
- 9 JUNCTION BOX FOR DDC CONTROL PANEL. COORDINATE EXACT LOCATION WITH MECHANICAL CONTRACTOR PRIOR TO ROUGH-IN.

**ENGINEERING MATRIX, INC.**  
 CONSULTING ENGINEERS  
 2800 SCHEERER DRIVE, SUITE 640  
 ST. PETERSBURG, FLORIDA 33716  
 (727) 372-4666 FAX (727) 371-8062 EMAIL: em@matrixinc.com  
 CERT. OF AUTHORIZATION NO. 4898 E.M. JOB NO. 19-0900  
 © 2019 Engineering Matrix, Inc. DRAWN BY: EM CHECKED BY: JSW

**FleischmanGarcia**  
 ARCHITECTS  
 2501 W. PARK AVENUE, SUITE 300  
 TAMPA, FLORIDA 33606  
 PHONE (813) 281-1400  
 FAX (813) 281-1900  
 REGISTRATION NUMBER: AA 000272

**Pasco County  
 Fire & Rescue Station  
 No. 17**  
 New Port Richey, Florida

THIS DESIGN AND DRAWING IS THE SOLE PROPERTY OF FLEISCHMAN-GARCIA ARCHITECTS. IT IS TO BE USED ONLY FOR THE PROJECT AND SITE SPECIFICALLY IDENTIFIED HEREIN. NO PART OF THIS WORK MAY BE REPRODUCED OR TRANSMITTED IN ANY FORM OR BY ANY MEANS, ELECTRONIC OR MECHANICAL, WITHOUT PERMISSION FROM FLEISCHMAN-GARCIA ARCHITECTS.

FGA PROJECT NUMBER  
**19039**

ISSUE DATE  
**05-25-20**

REVISIONS	
△	DATE: _____
△	DATE: _____
△	DATE: _____

SHEET NUMBER  
**E3.2**

POWER SECOND FLOOR PLAN A3  
1/8"=1'

KEYED NOTES A1  
NTS